



These drawings were prepared by me, or under my  
close personal supervision, and to my best  
knowledge and belief comply with all City codes  
and ordinances. I am not administering the  
work.

John L. Schackal, III Architect Reg. No. 2990

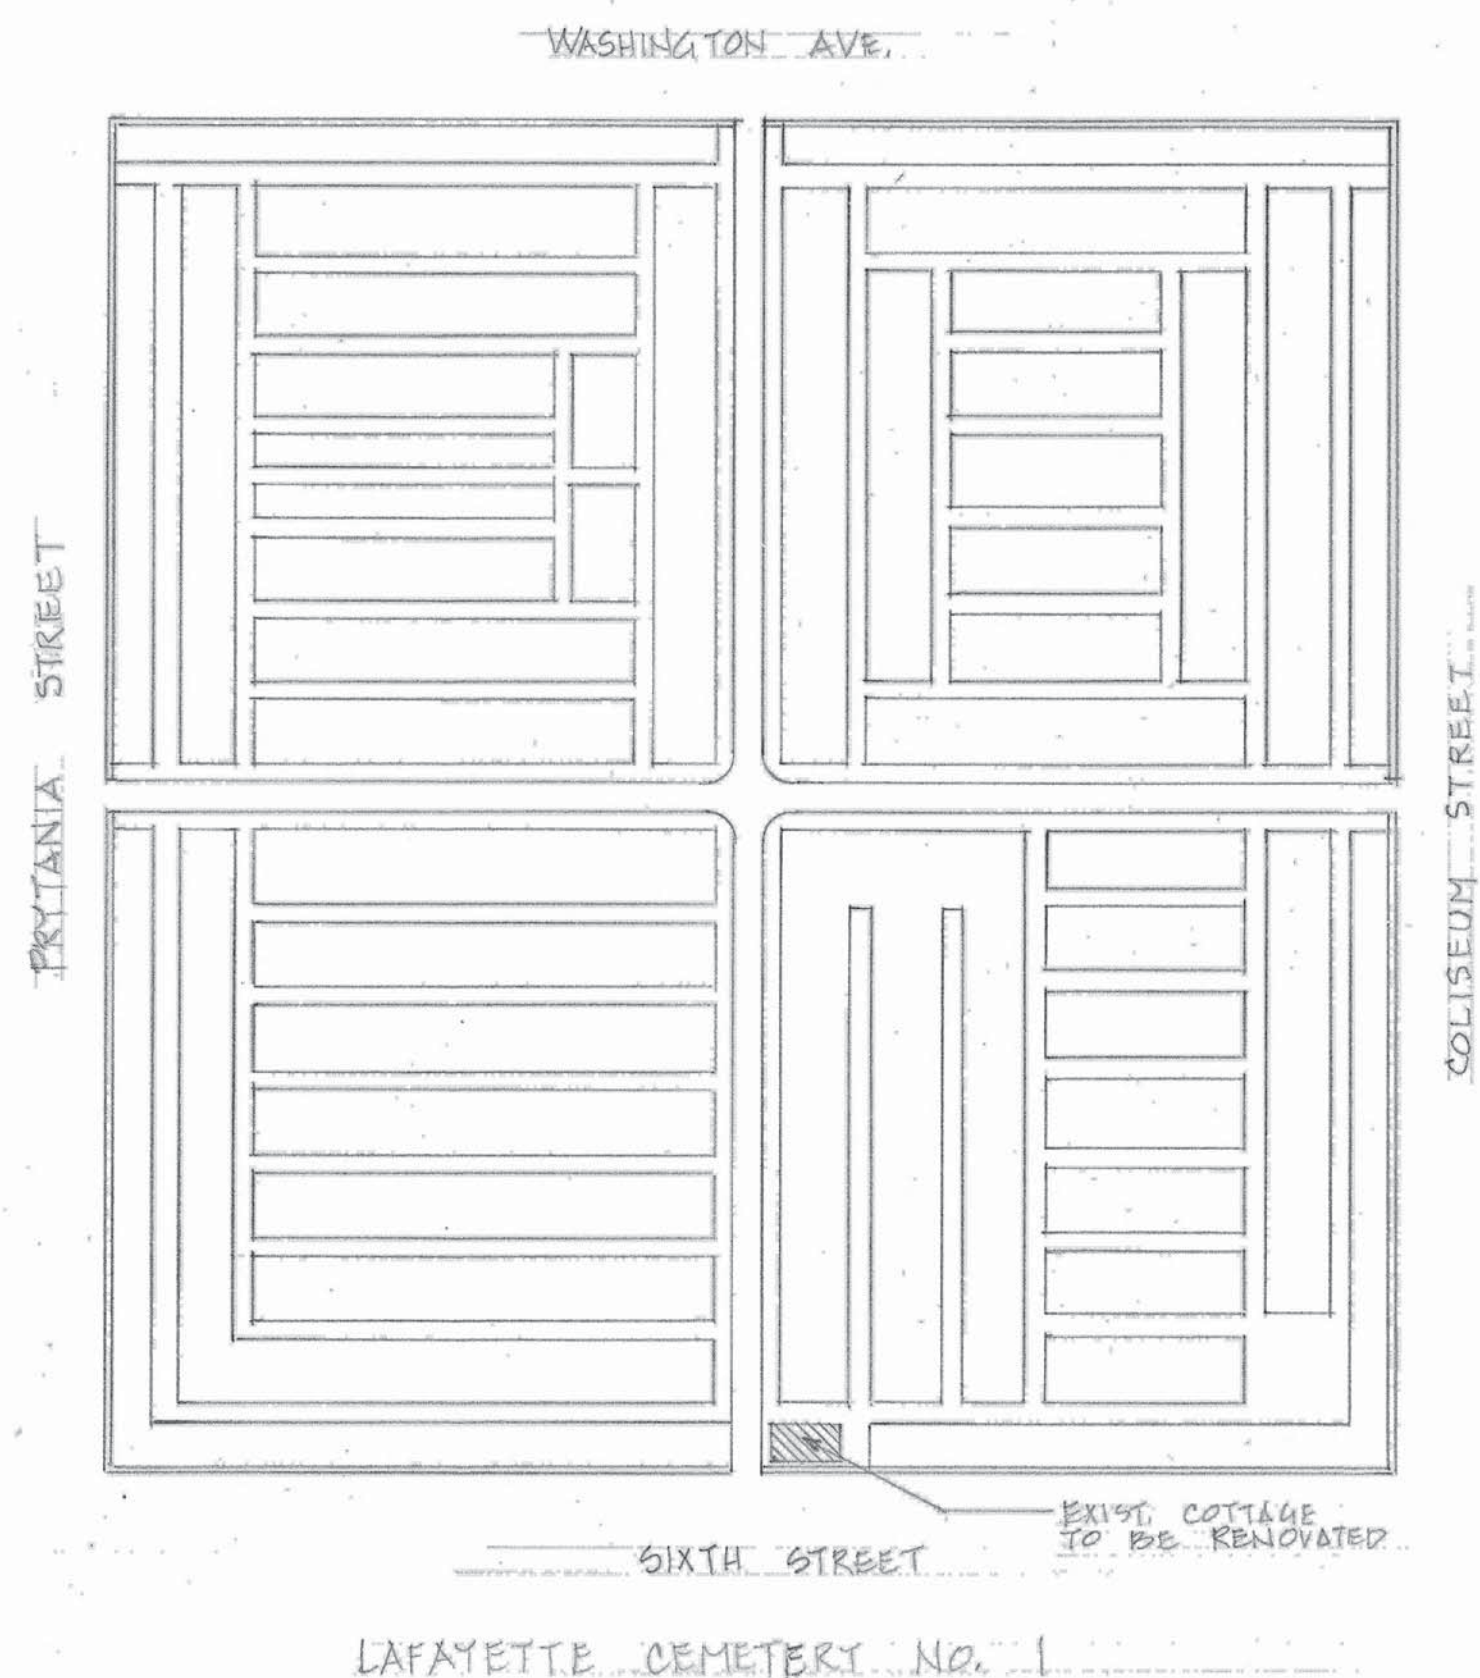


1 LOCATION PLAN  
A1 SCALE: 1/4" = 1'-0"

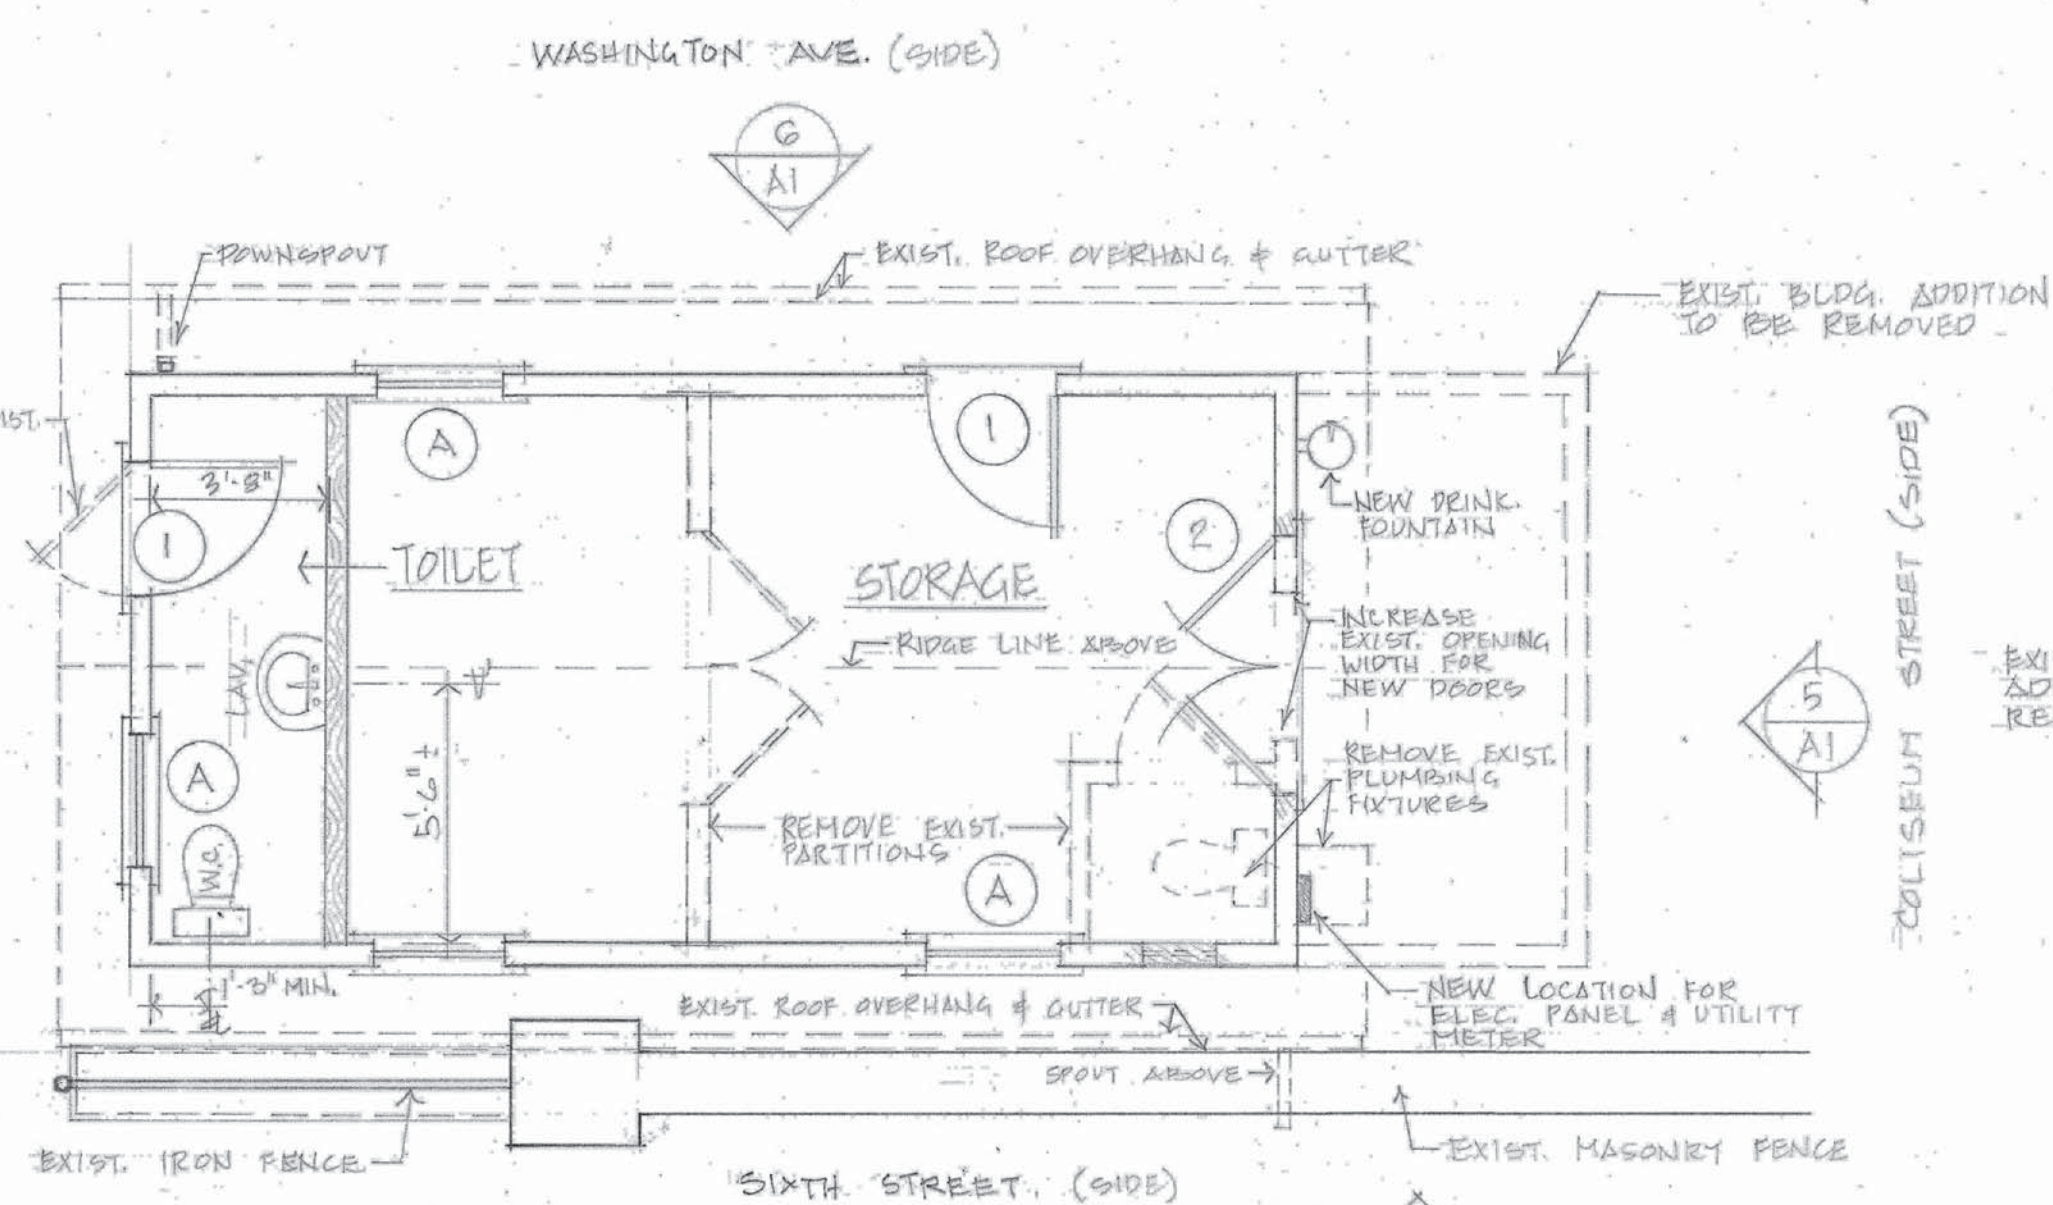


2 FLOOR PLAN  
A1 SCALE: 1/4" = 1'-0"

NOTES: INTERIOR FINISHES INCLUDE TRAWELED  
SMOOTH CONCRETE FLOOR & PAINTED  
PLYWOOD WALLS & CEILINGS

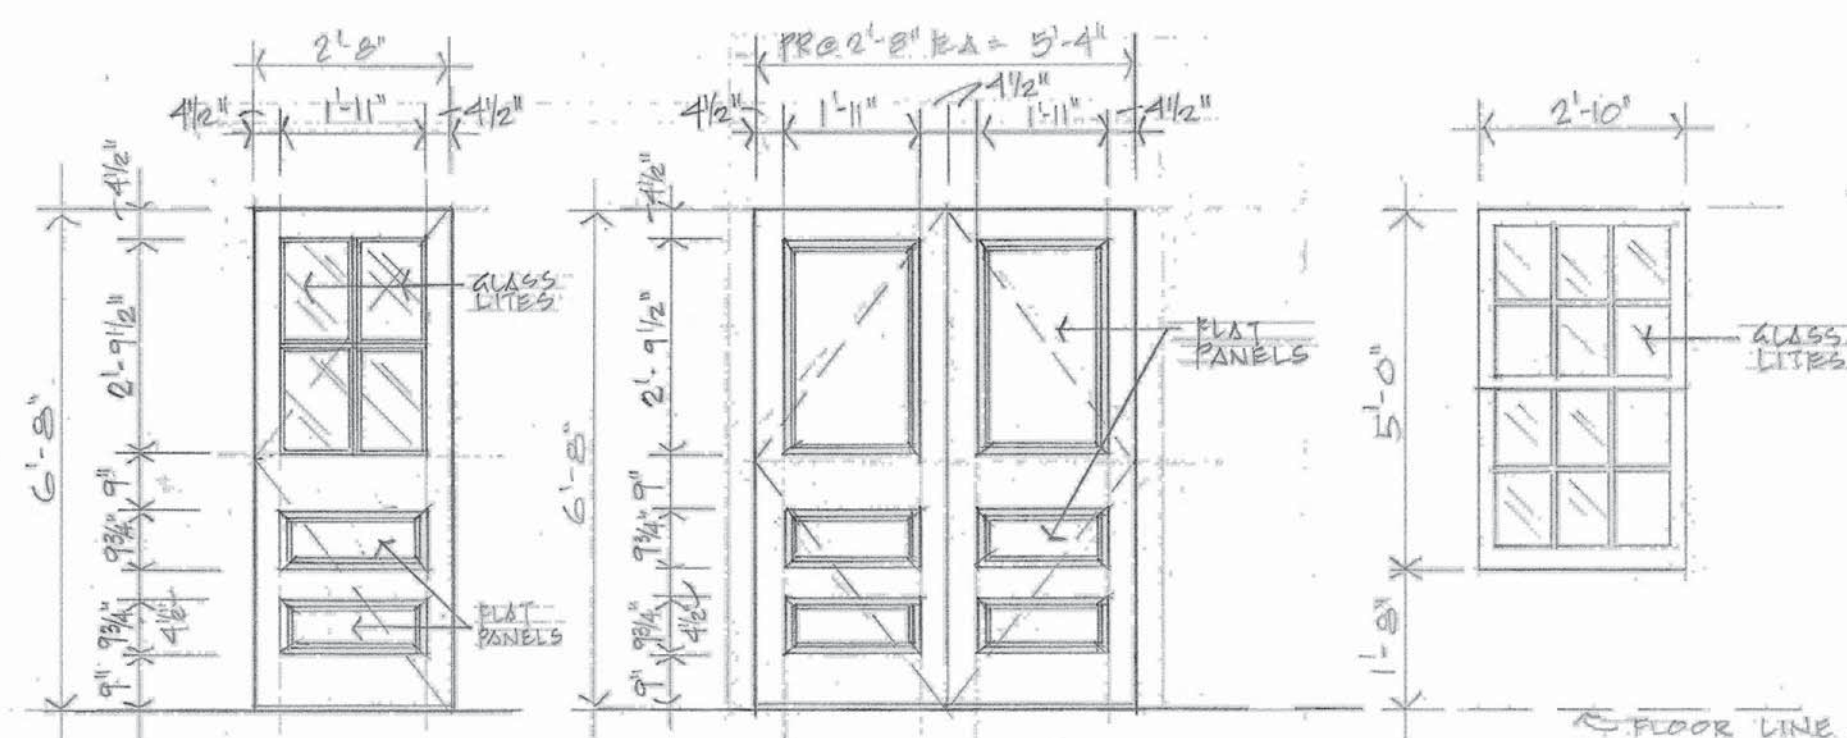


3 WINDOW & DOOR TYPES  
A1 SCALE: 3/8" = 1'-0"

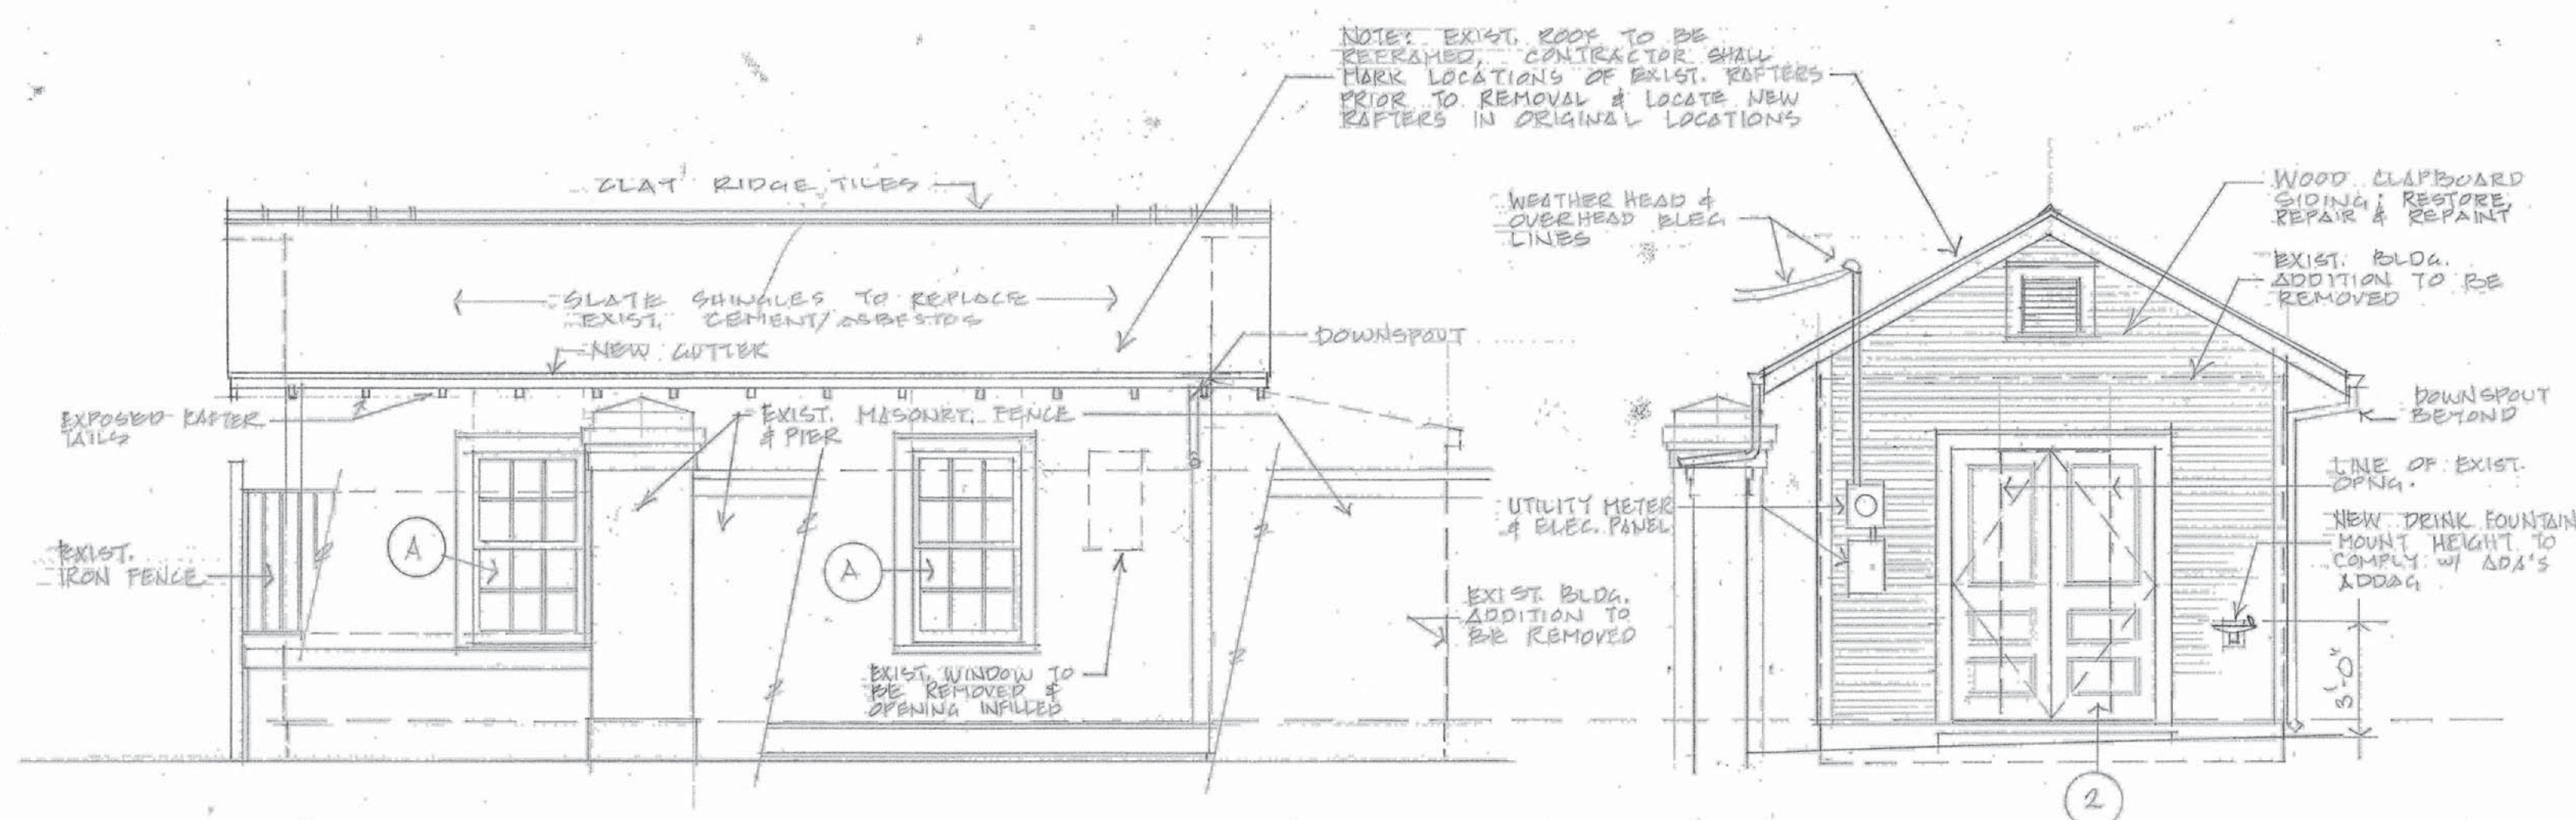

4 SIXTH STREET (SIDE) ELEVATION  
A1 SCALE: 1/4" = 1'-0"

5 COLISEUM STREET (SIDE) ELEVATION  
A1 SCALE: 1/4" = 1'-0"

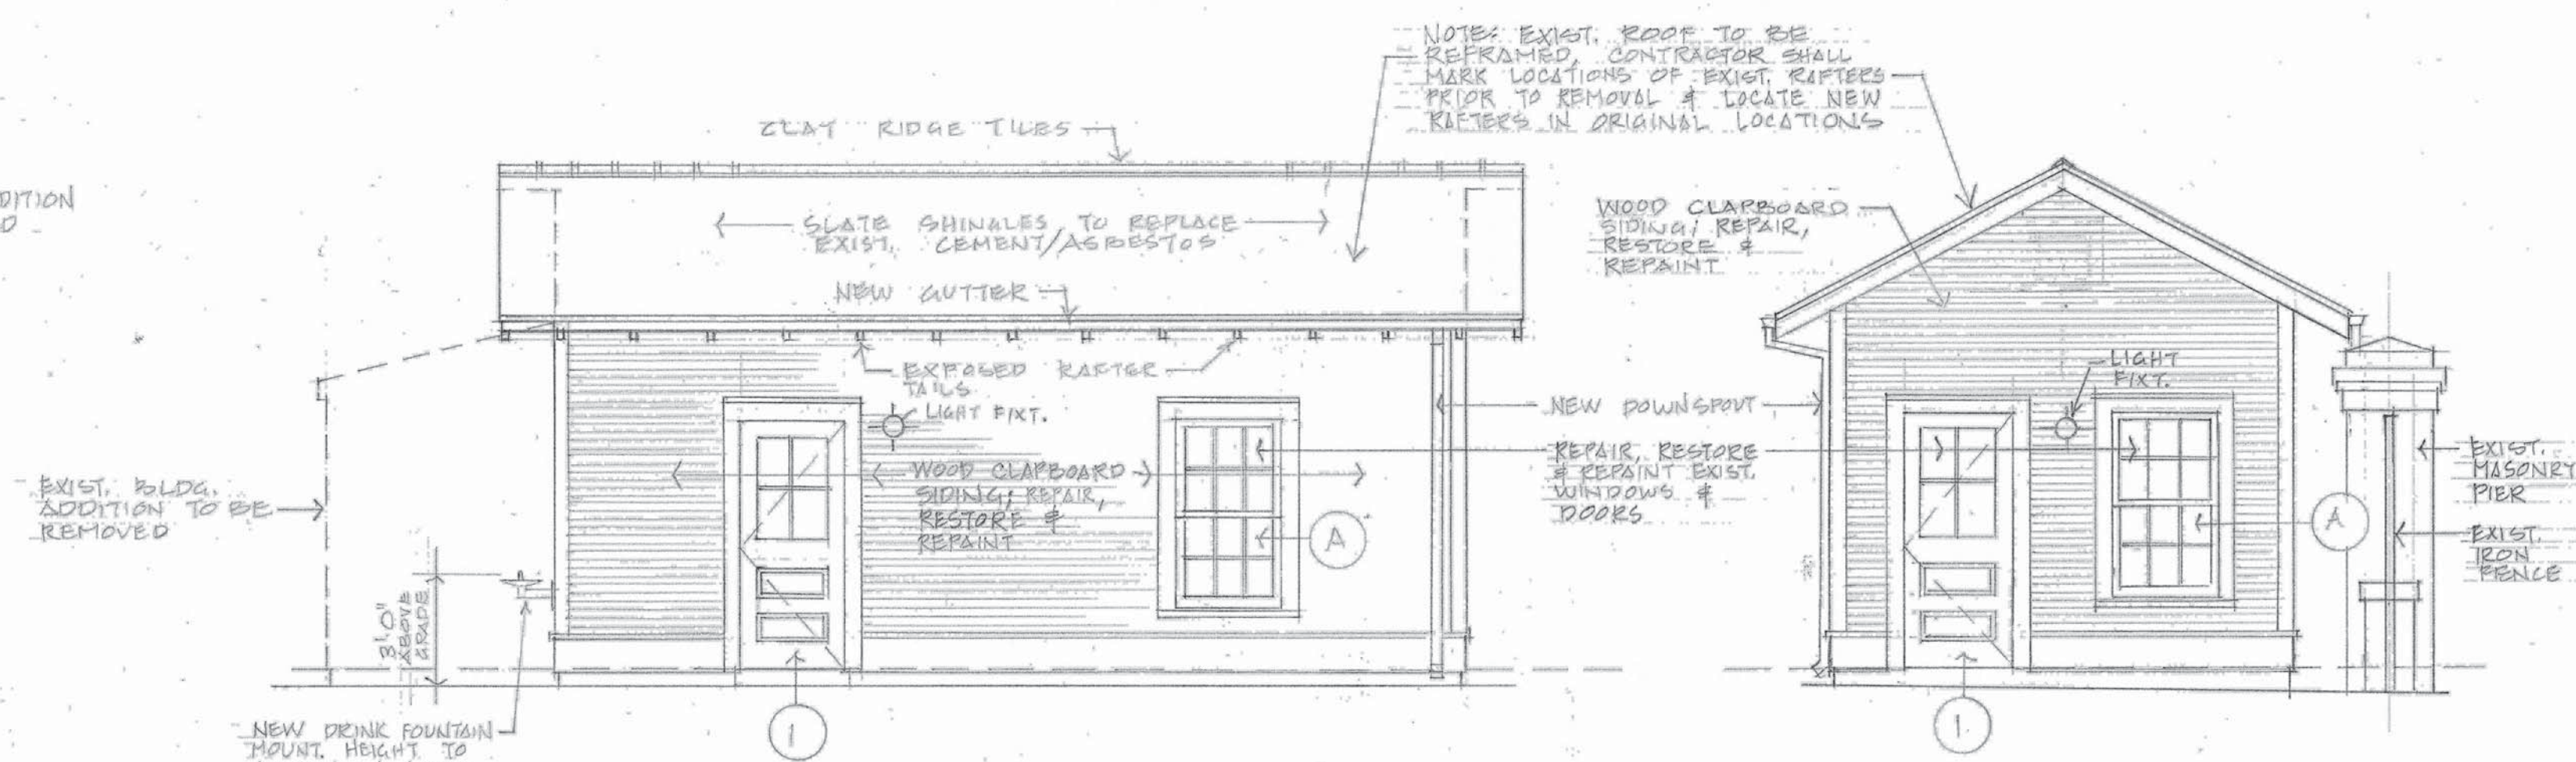

6 WASHINGTON AVE. (SIDE) ELEVATION  
A1 SCALE: 1/4" = 1'-0"

7 PRYTANIA ST. (SIDE) ELEVATION  
A1 SCALE: 1/4" = 1'-0"

Restoration of Sexton Cottages  
Lafayette Cemetery No. 1 & 2  
New Orleans, Louisiana

PROJECT #		
TYPE		
DRAWN BY	MR	
CHECKED BY		
ISSUE DATE	1/24/2013	
REVISION #	DESCRIPTION DATE	


A-1

These drawings were prepared by me, or under my close personal supervision, and to my best knowledge and belief comply with all City codes and ordinances. I am not administering the work.


John L. Schackai, III Architect Reg. No. 2990

**Restoration of Sexton Cottages**  
**Lafayette Cemetery No. 1 & 2**  
 New Orleans, Louisiana


PROJECT #		
TYPE		
DRAWN BY	HR	
CHECKED BY		
ISSUE DATE	1/24/2012	
REVISION #	DESCRIPTION DATE	

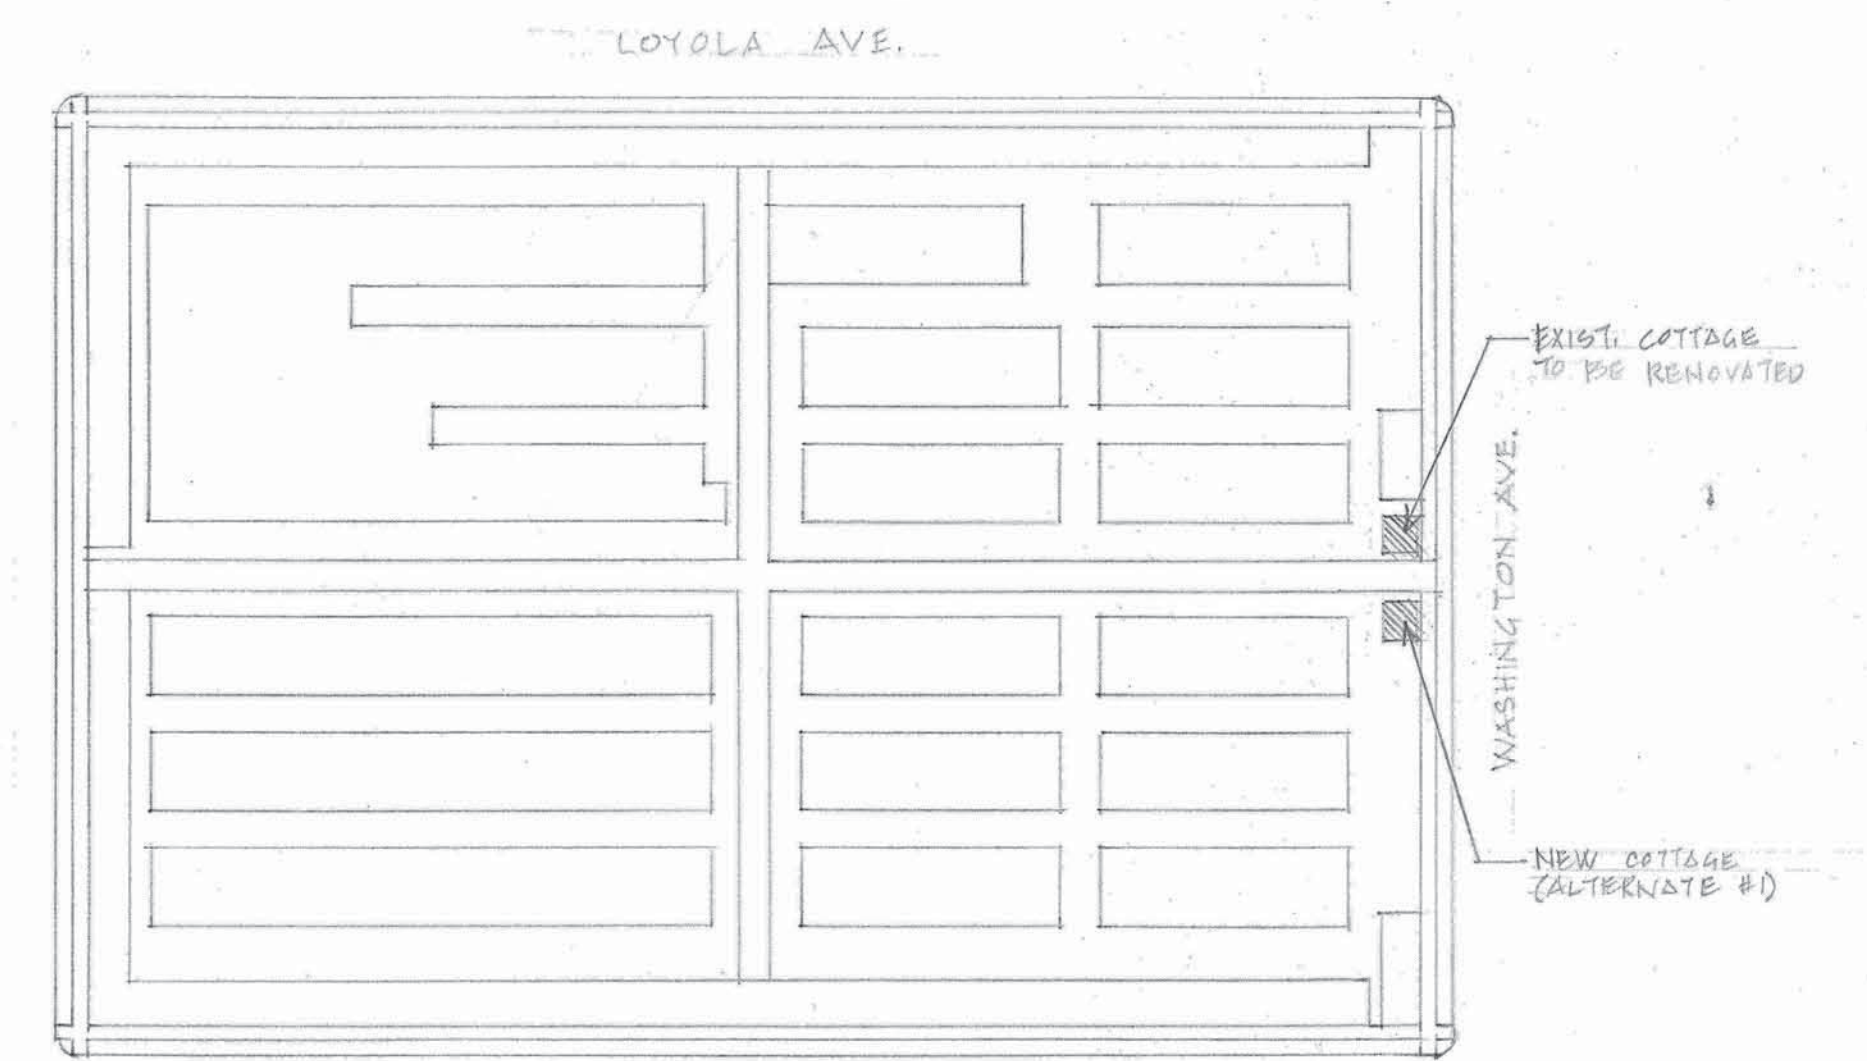

**1 LOCATION PLAN**  
 SCALE: 1/64" = 1'-0"

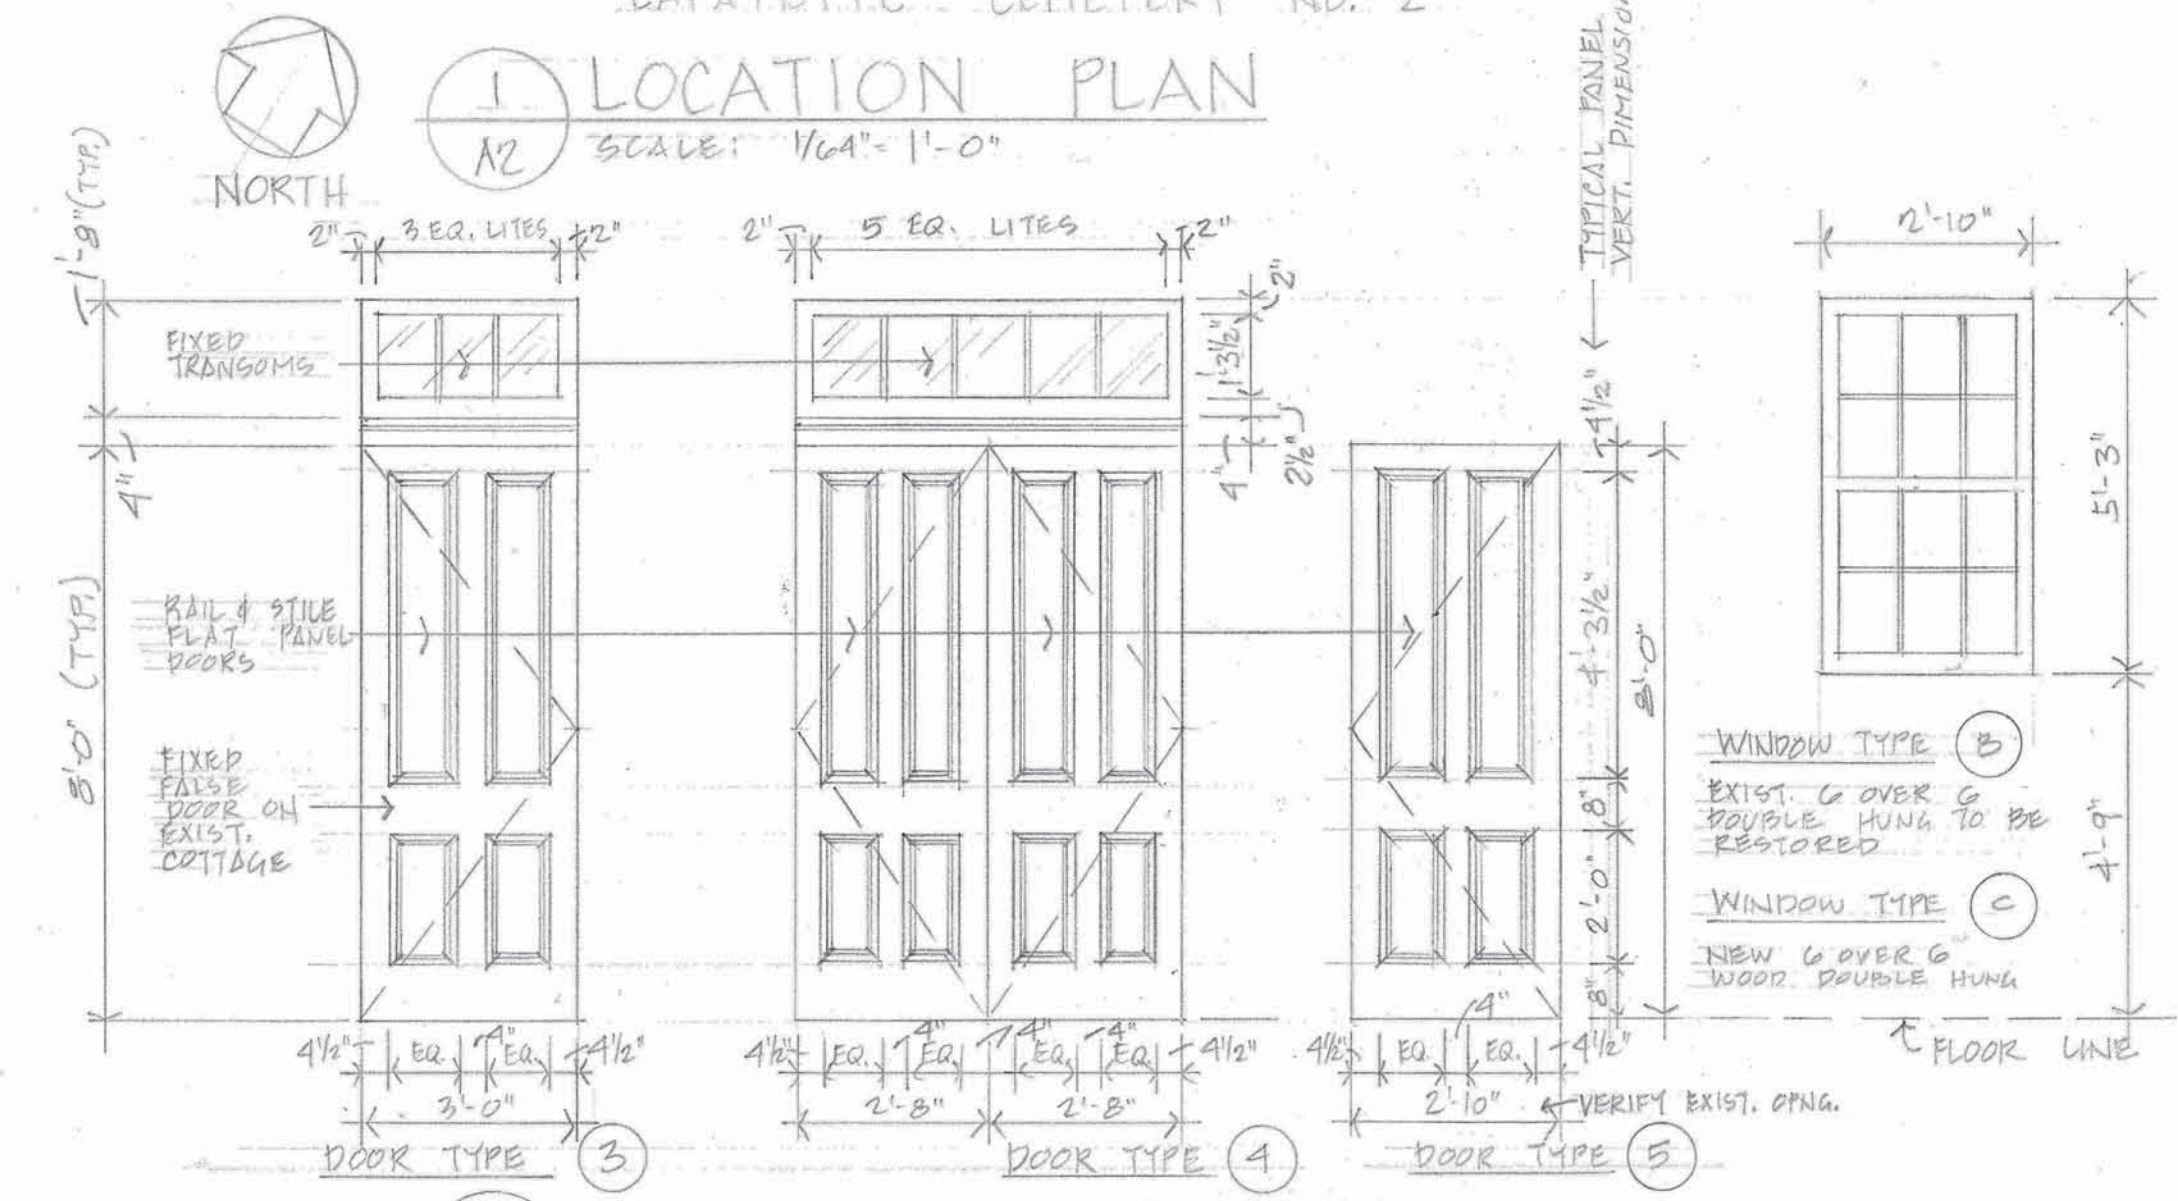


**2 WINDOW & DOOR TYPES**  
 SCALE: 3/8" = 1'-0"

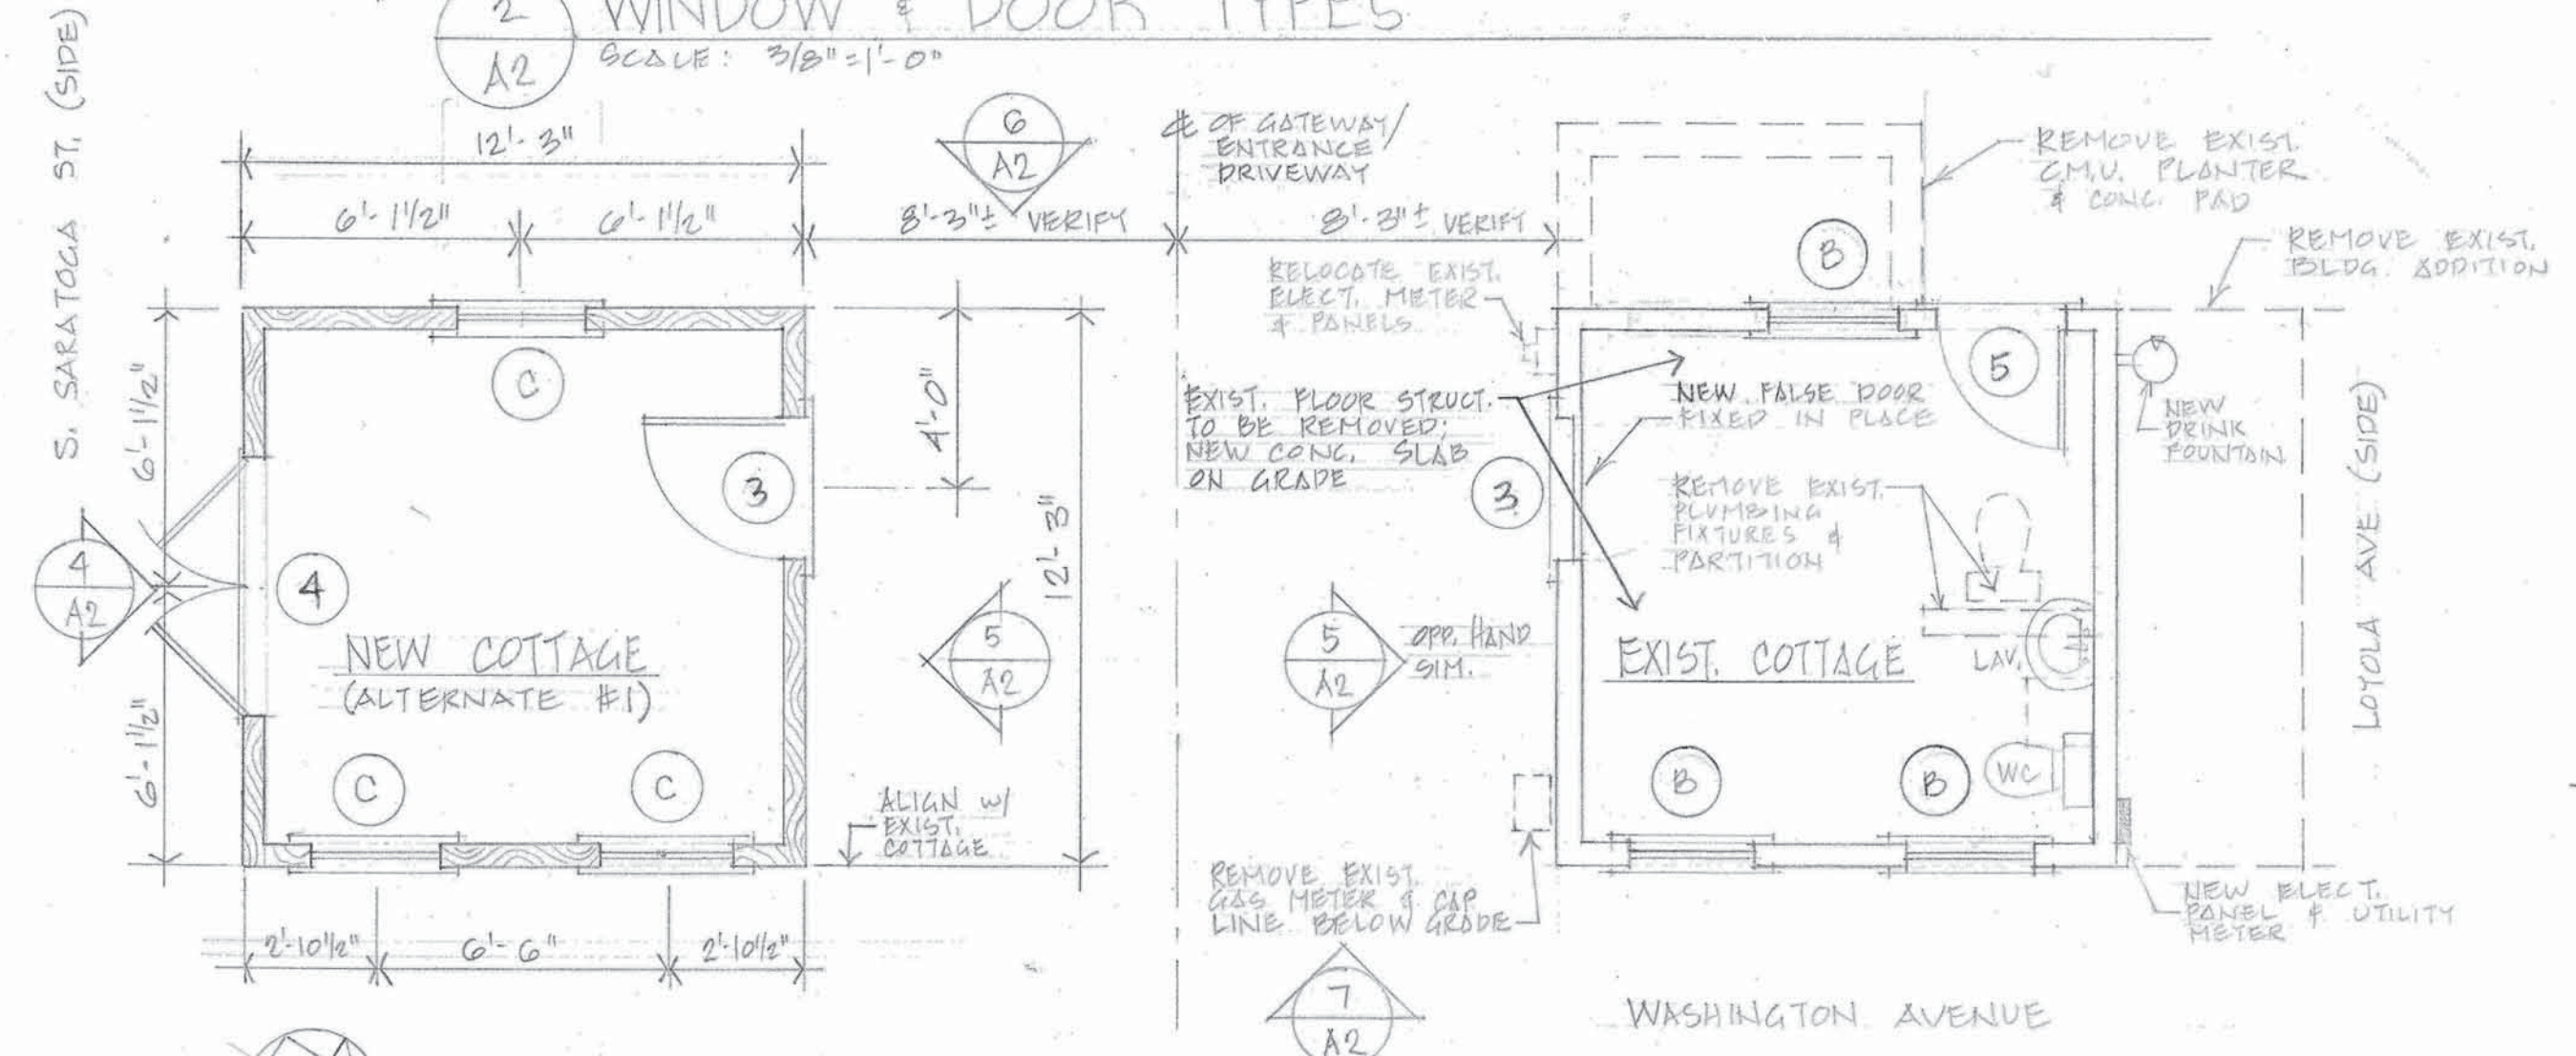


**3 FLOOR PLAN**  
 SCALE: 1/4" = 1'-0"

NOTE: INTERIOR FINISHES INCLUDE TROWELED SMOOTH CONCRETE FLOORS & PAINTED PLTWOOD WALLS & CEILINGS

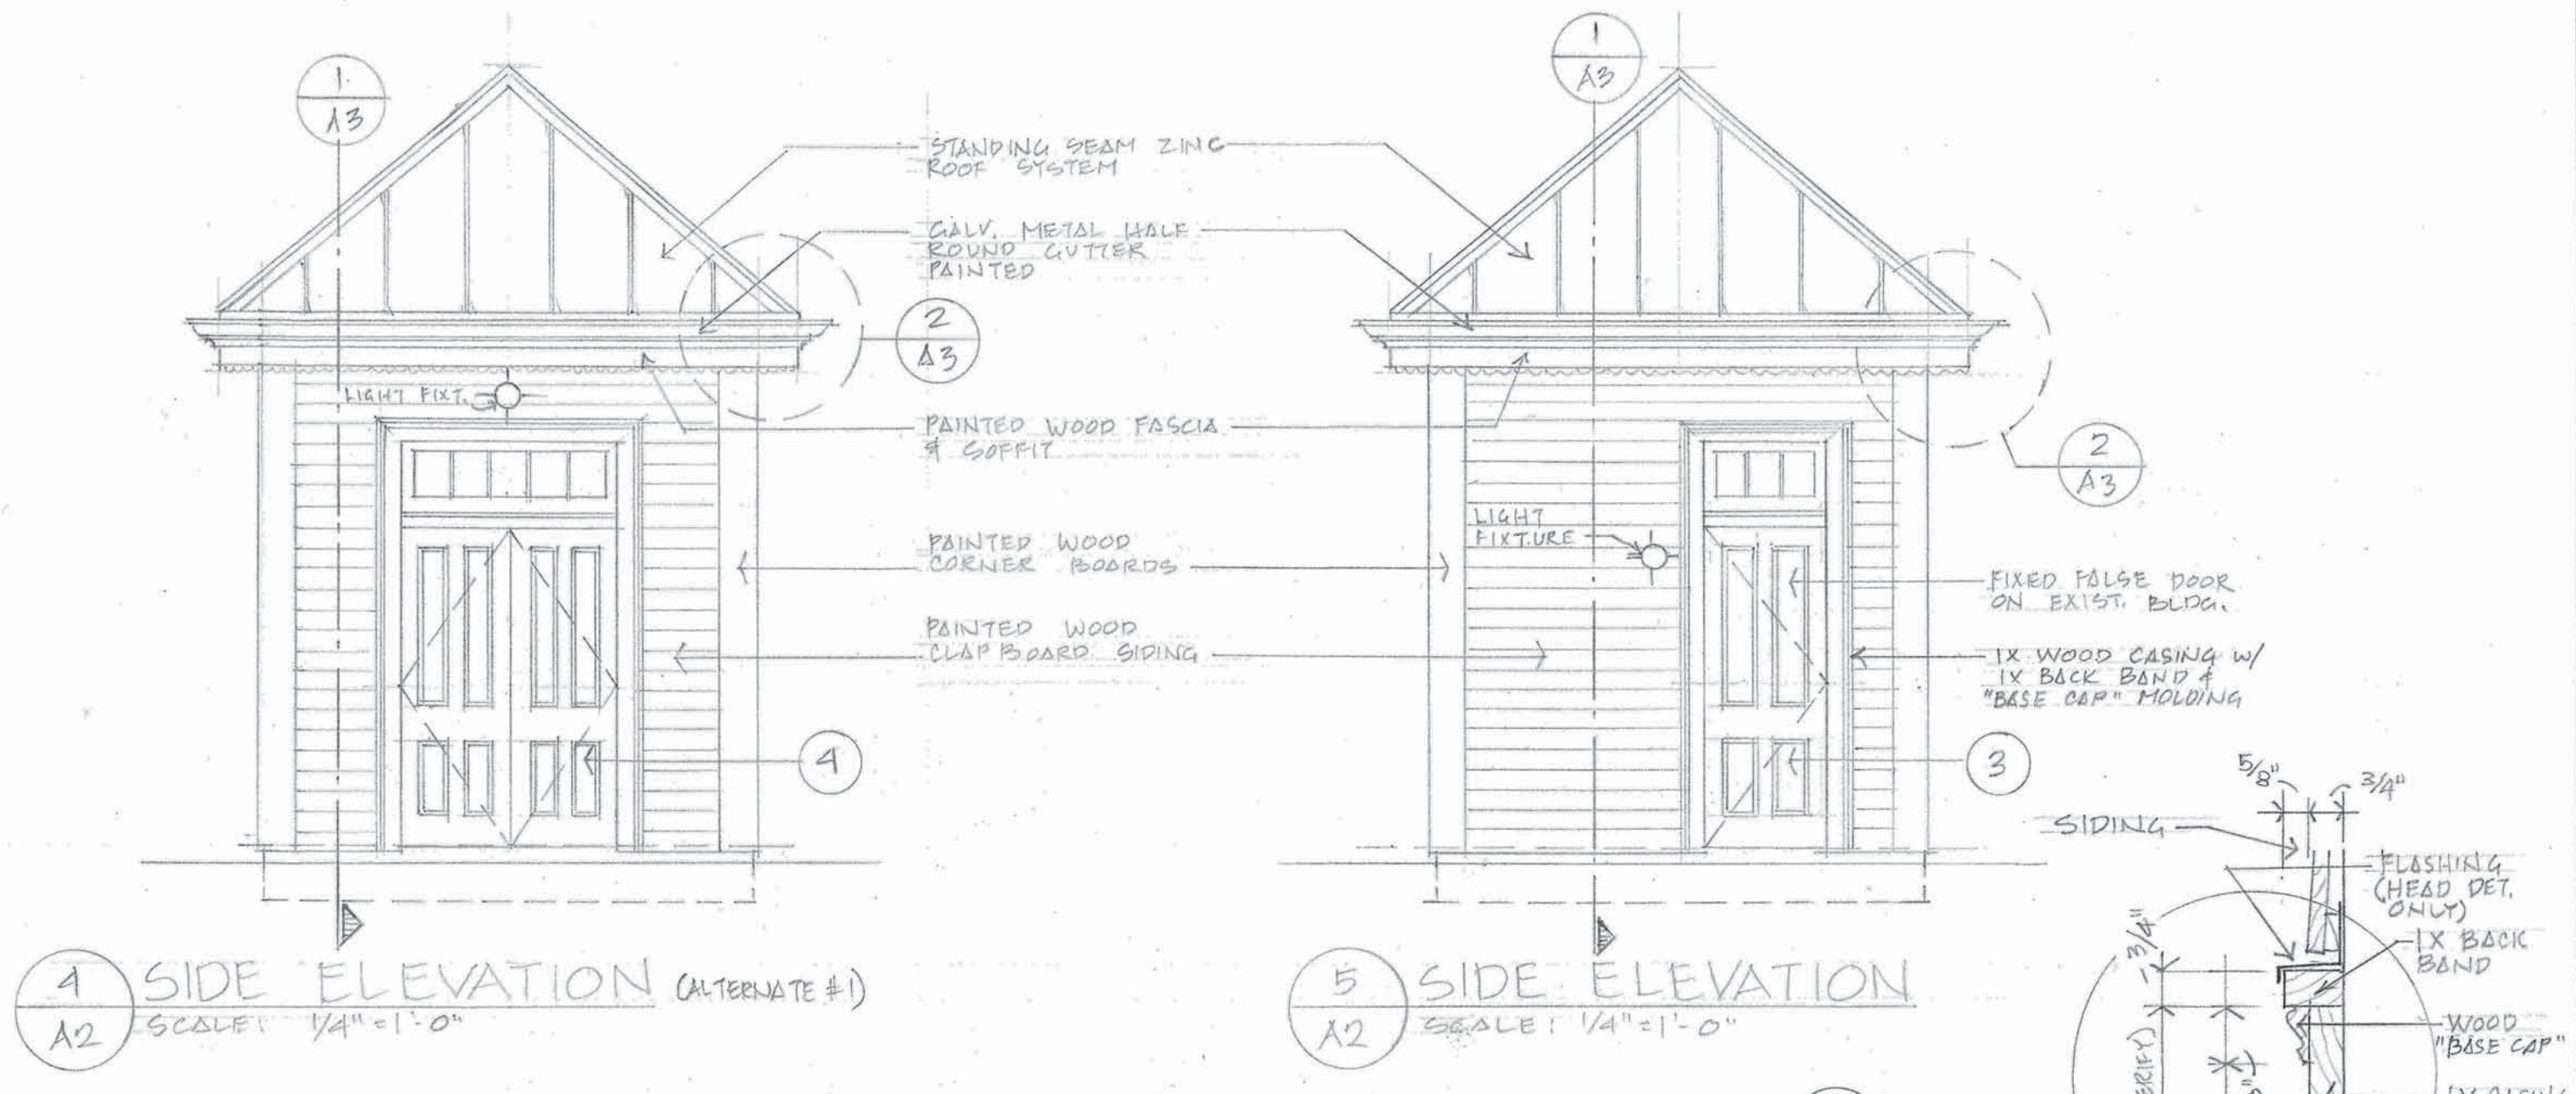


**4 SIDE ELEVATION (ALTERNATE #1)**  
 SCALE: 1/4" = 1'-0"


**5 SIDE ELEVATION**  
 SCALE: 1/4" = 1'-0"

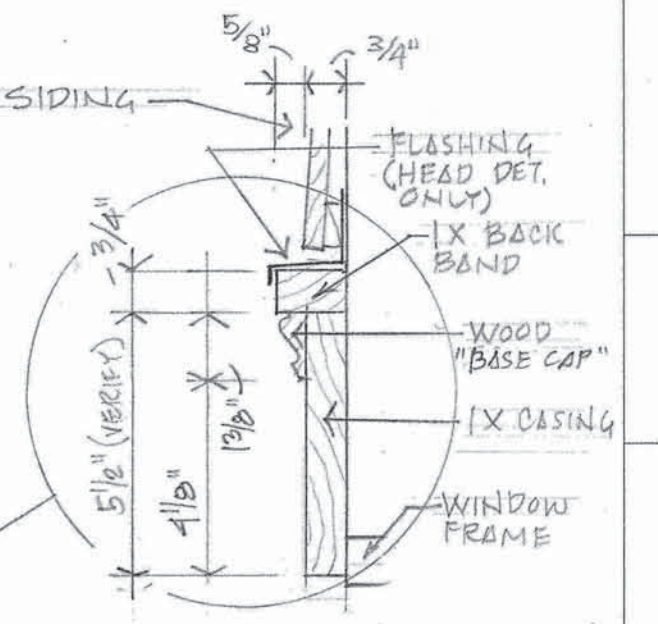

**TYP. WOOD TRIM**  
 SCALE: 3/8" = 1'-0"  
 (LAFAYETTE #2 ONLY)  
 NOTE: JAMB DET. SIMILAR

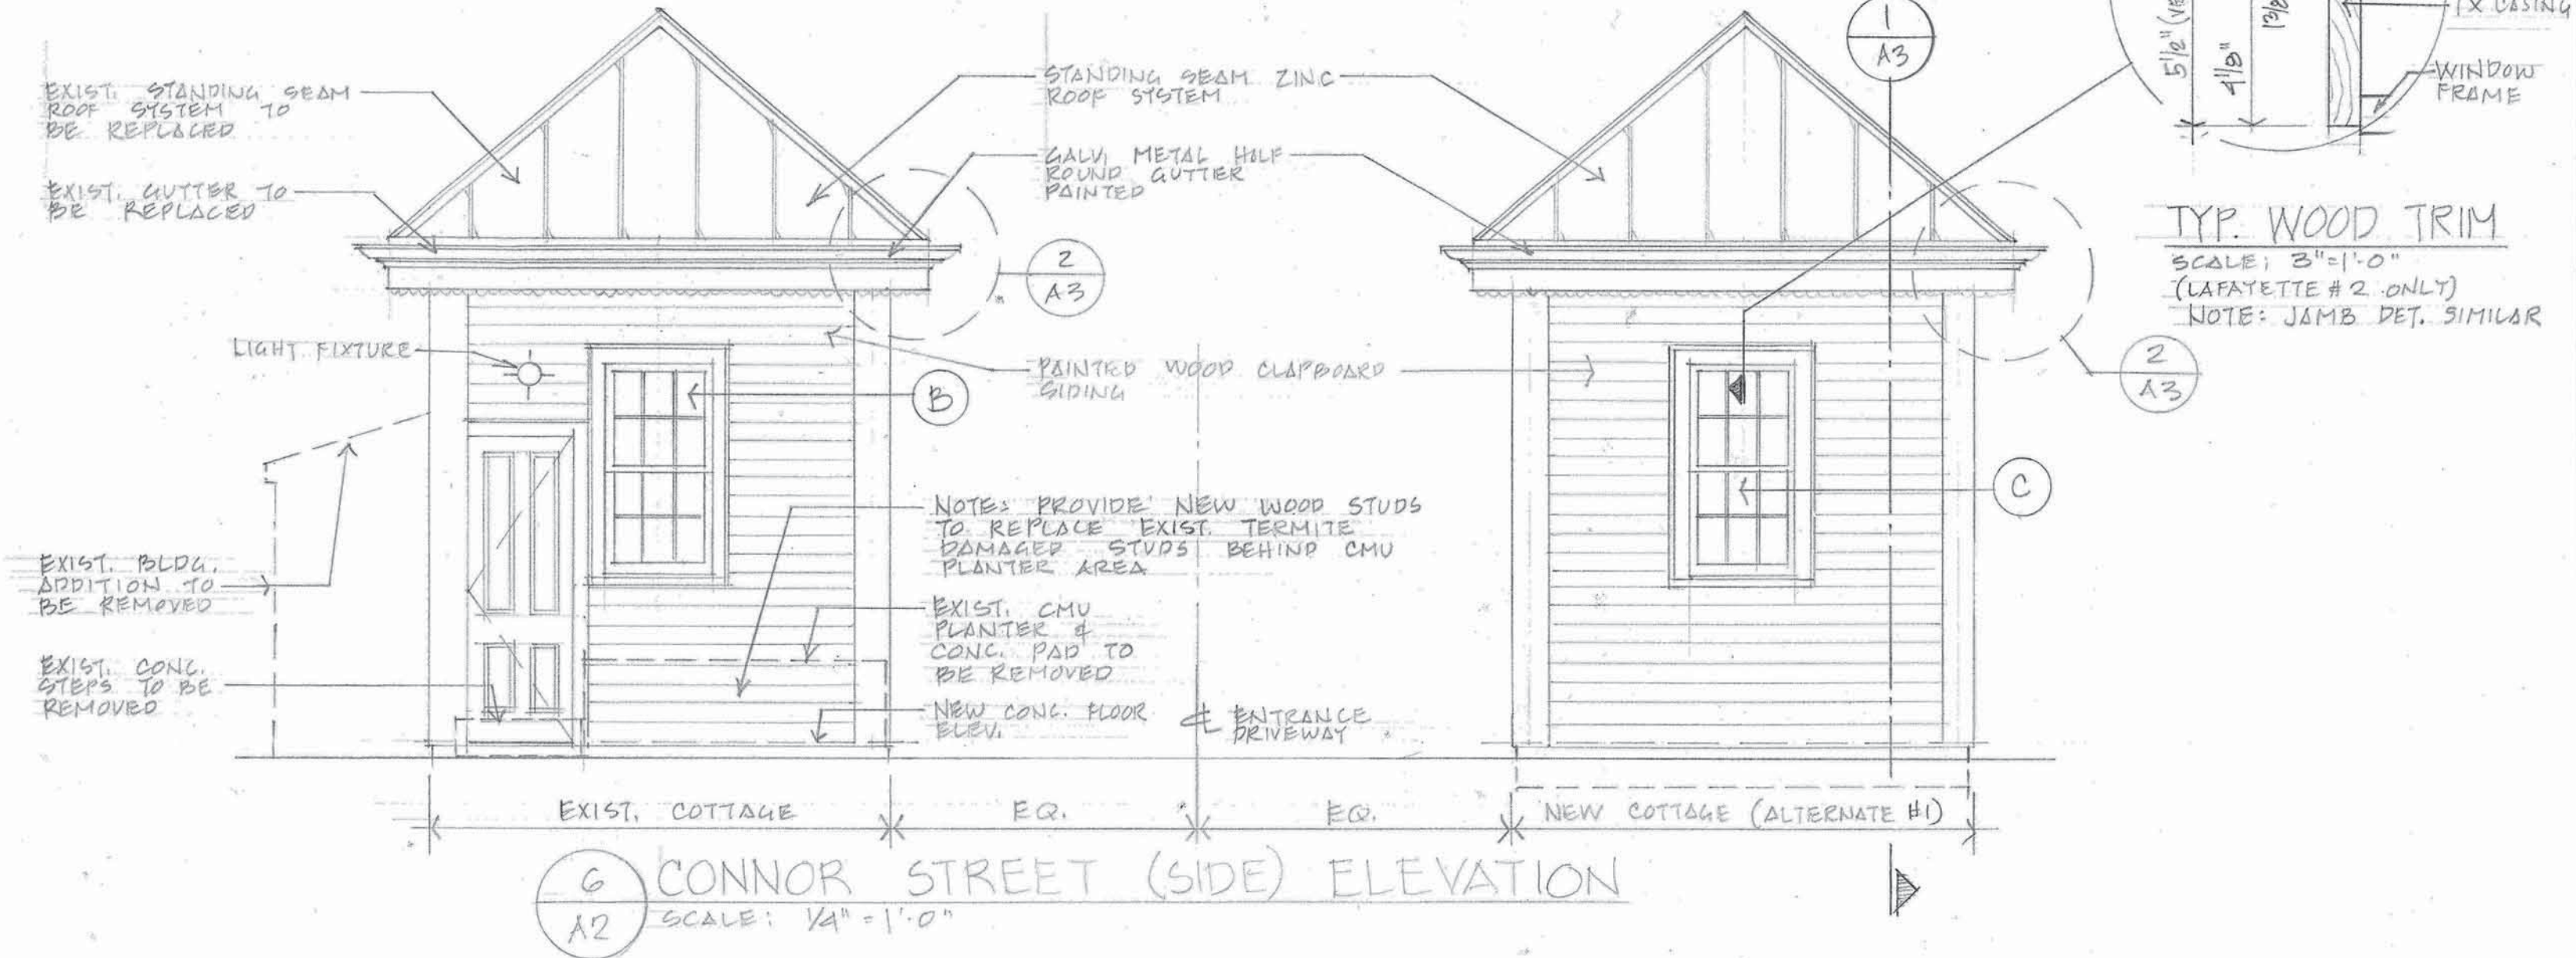



**6 CONNOR STREET (SIDE) ELEVATION**  
 SCALE: 1/4" = 1'-0"

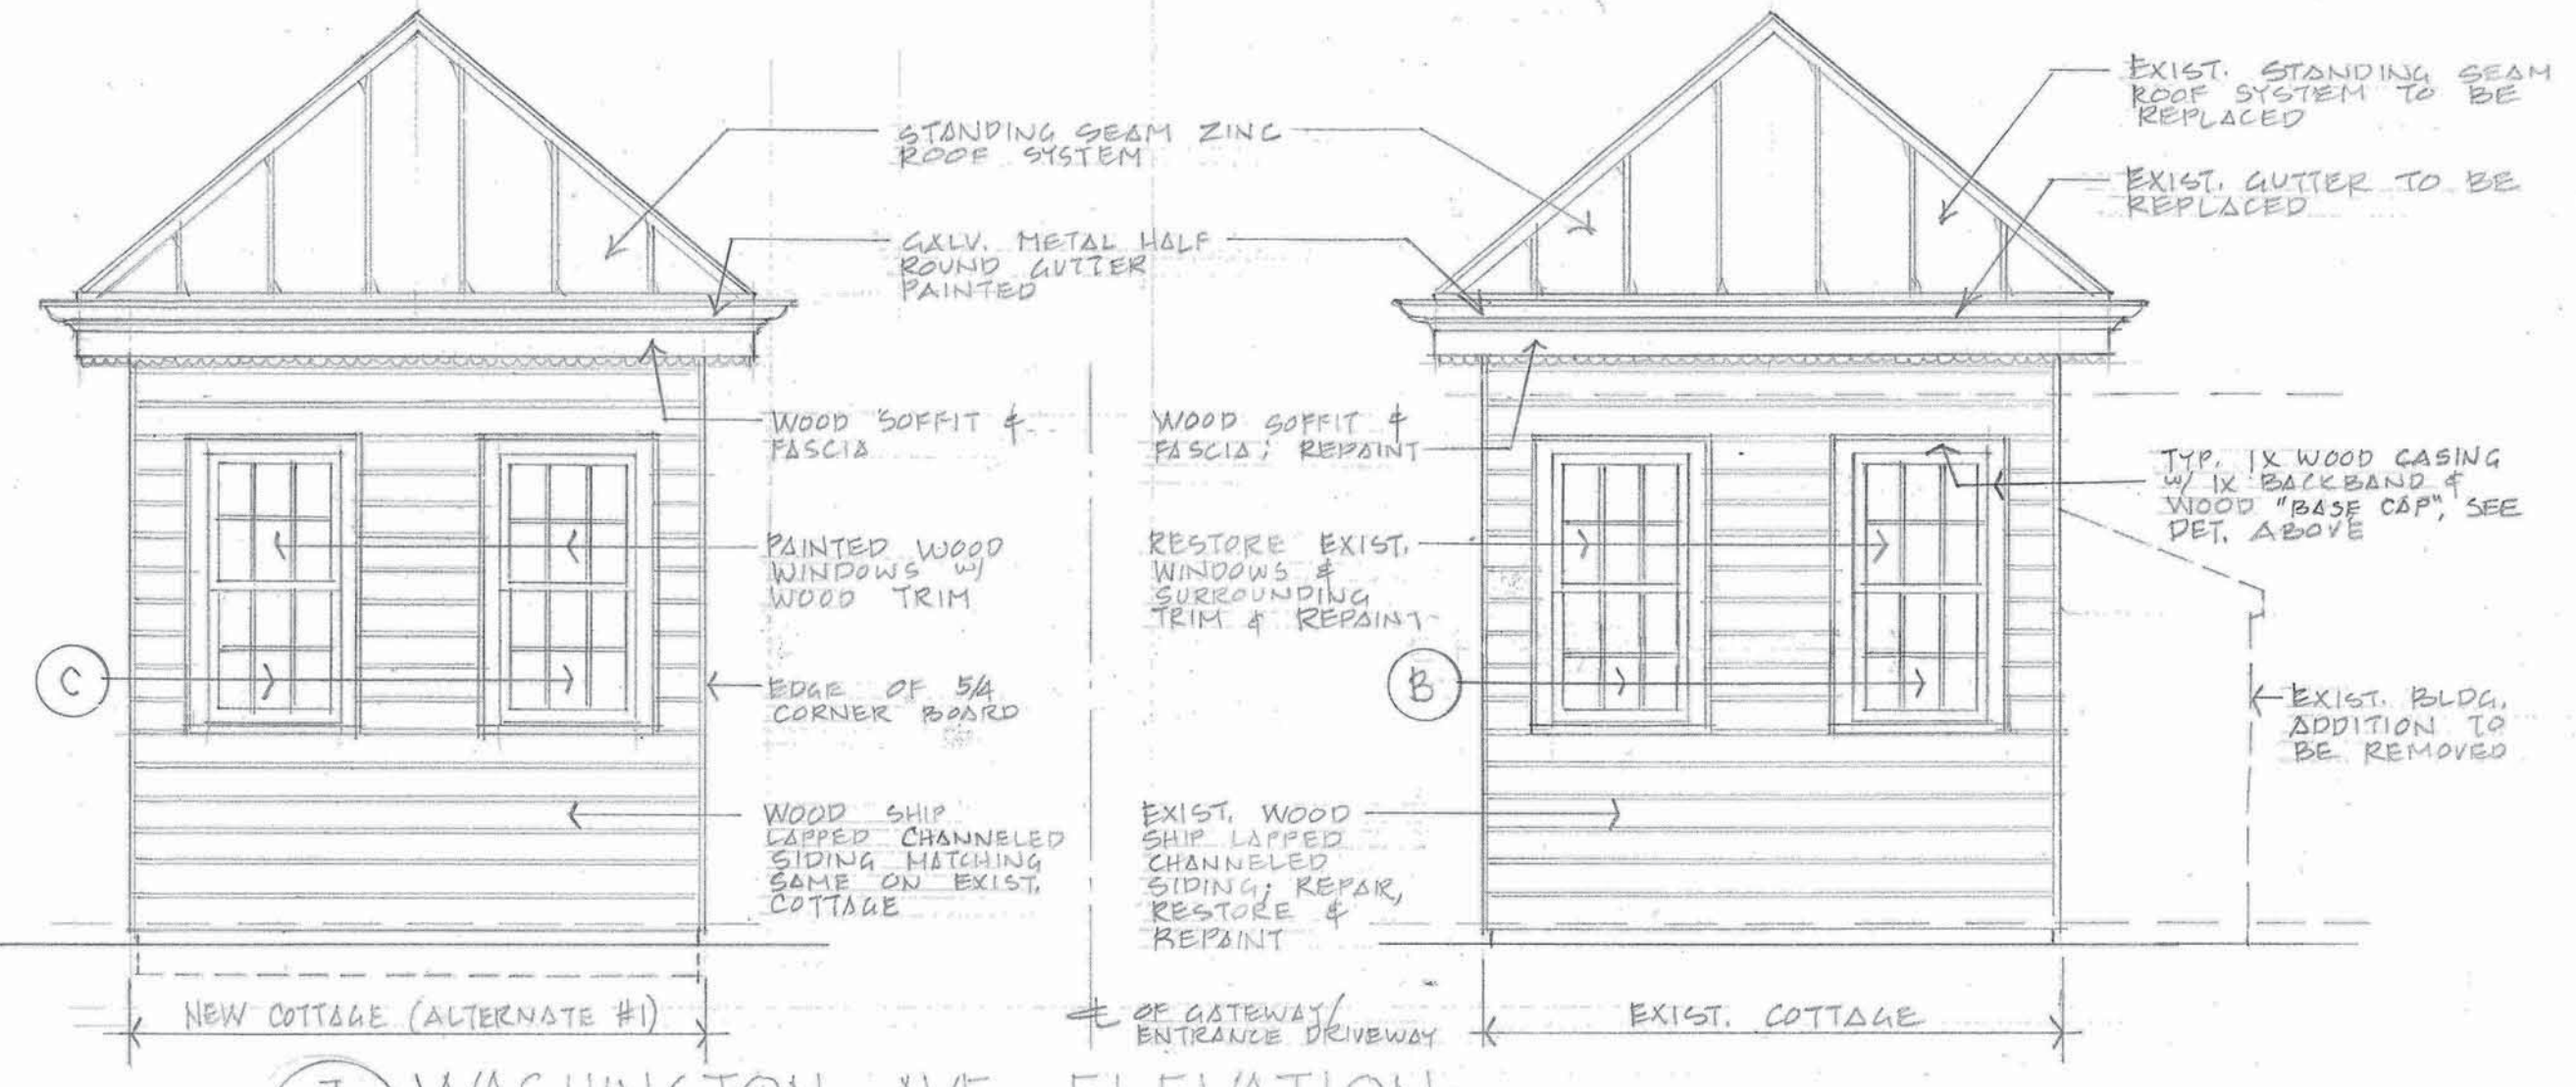


**7 WASHINGTON AVE. ELEVATION**  
 SCALE: 1/4" = 1'-0"

These drawings were prepared by me, or under my close personal supervision, and to my best knowledge and belief comply with all City codes and ordinances. I am not administering the work.


John L. Schackai, III Architect Reg. No. 2990

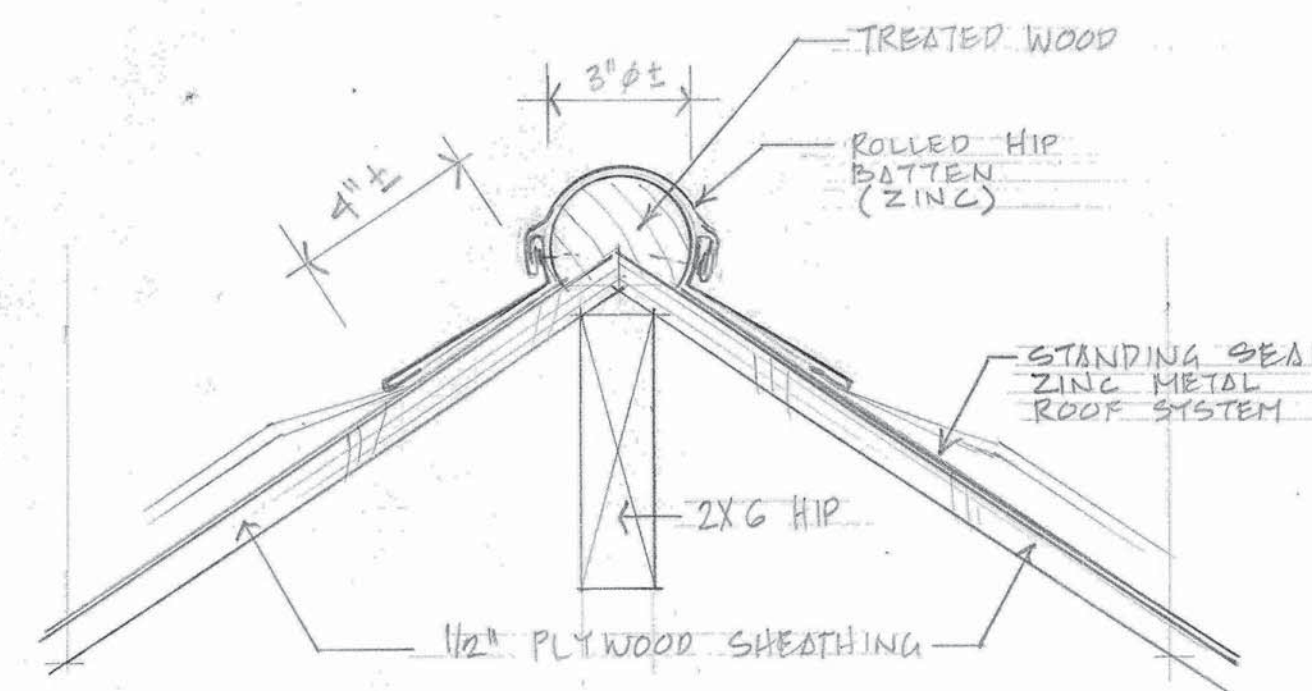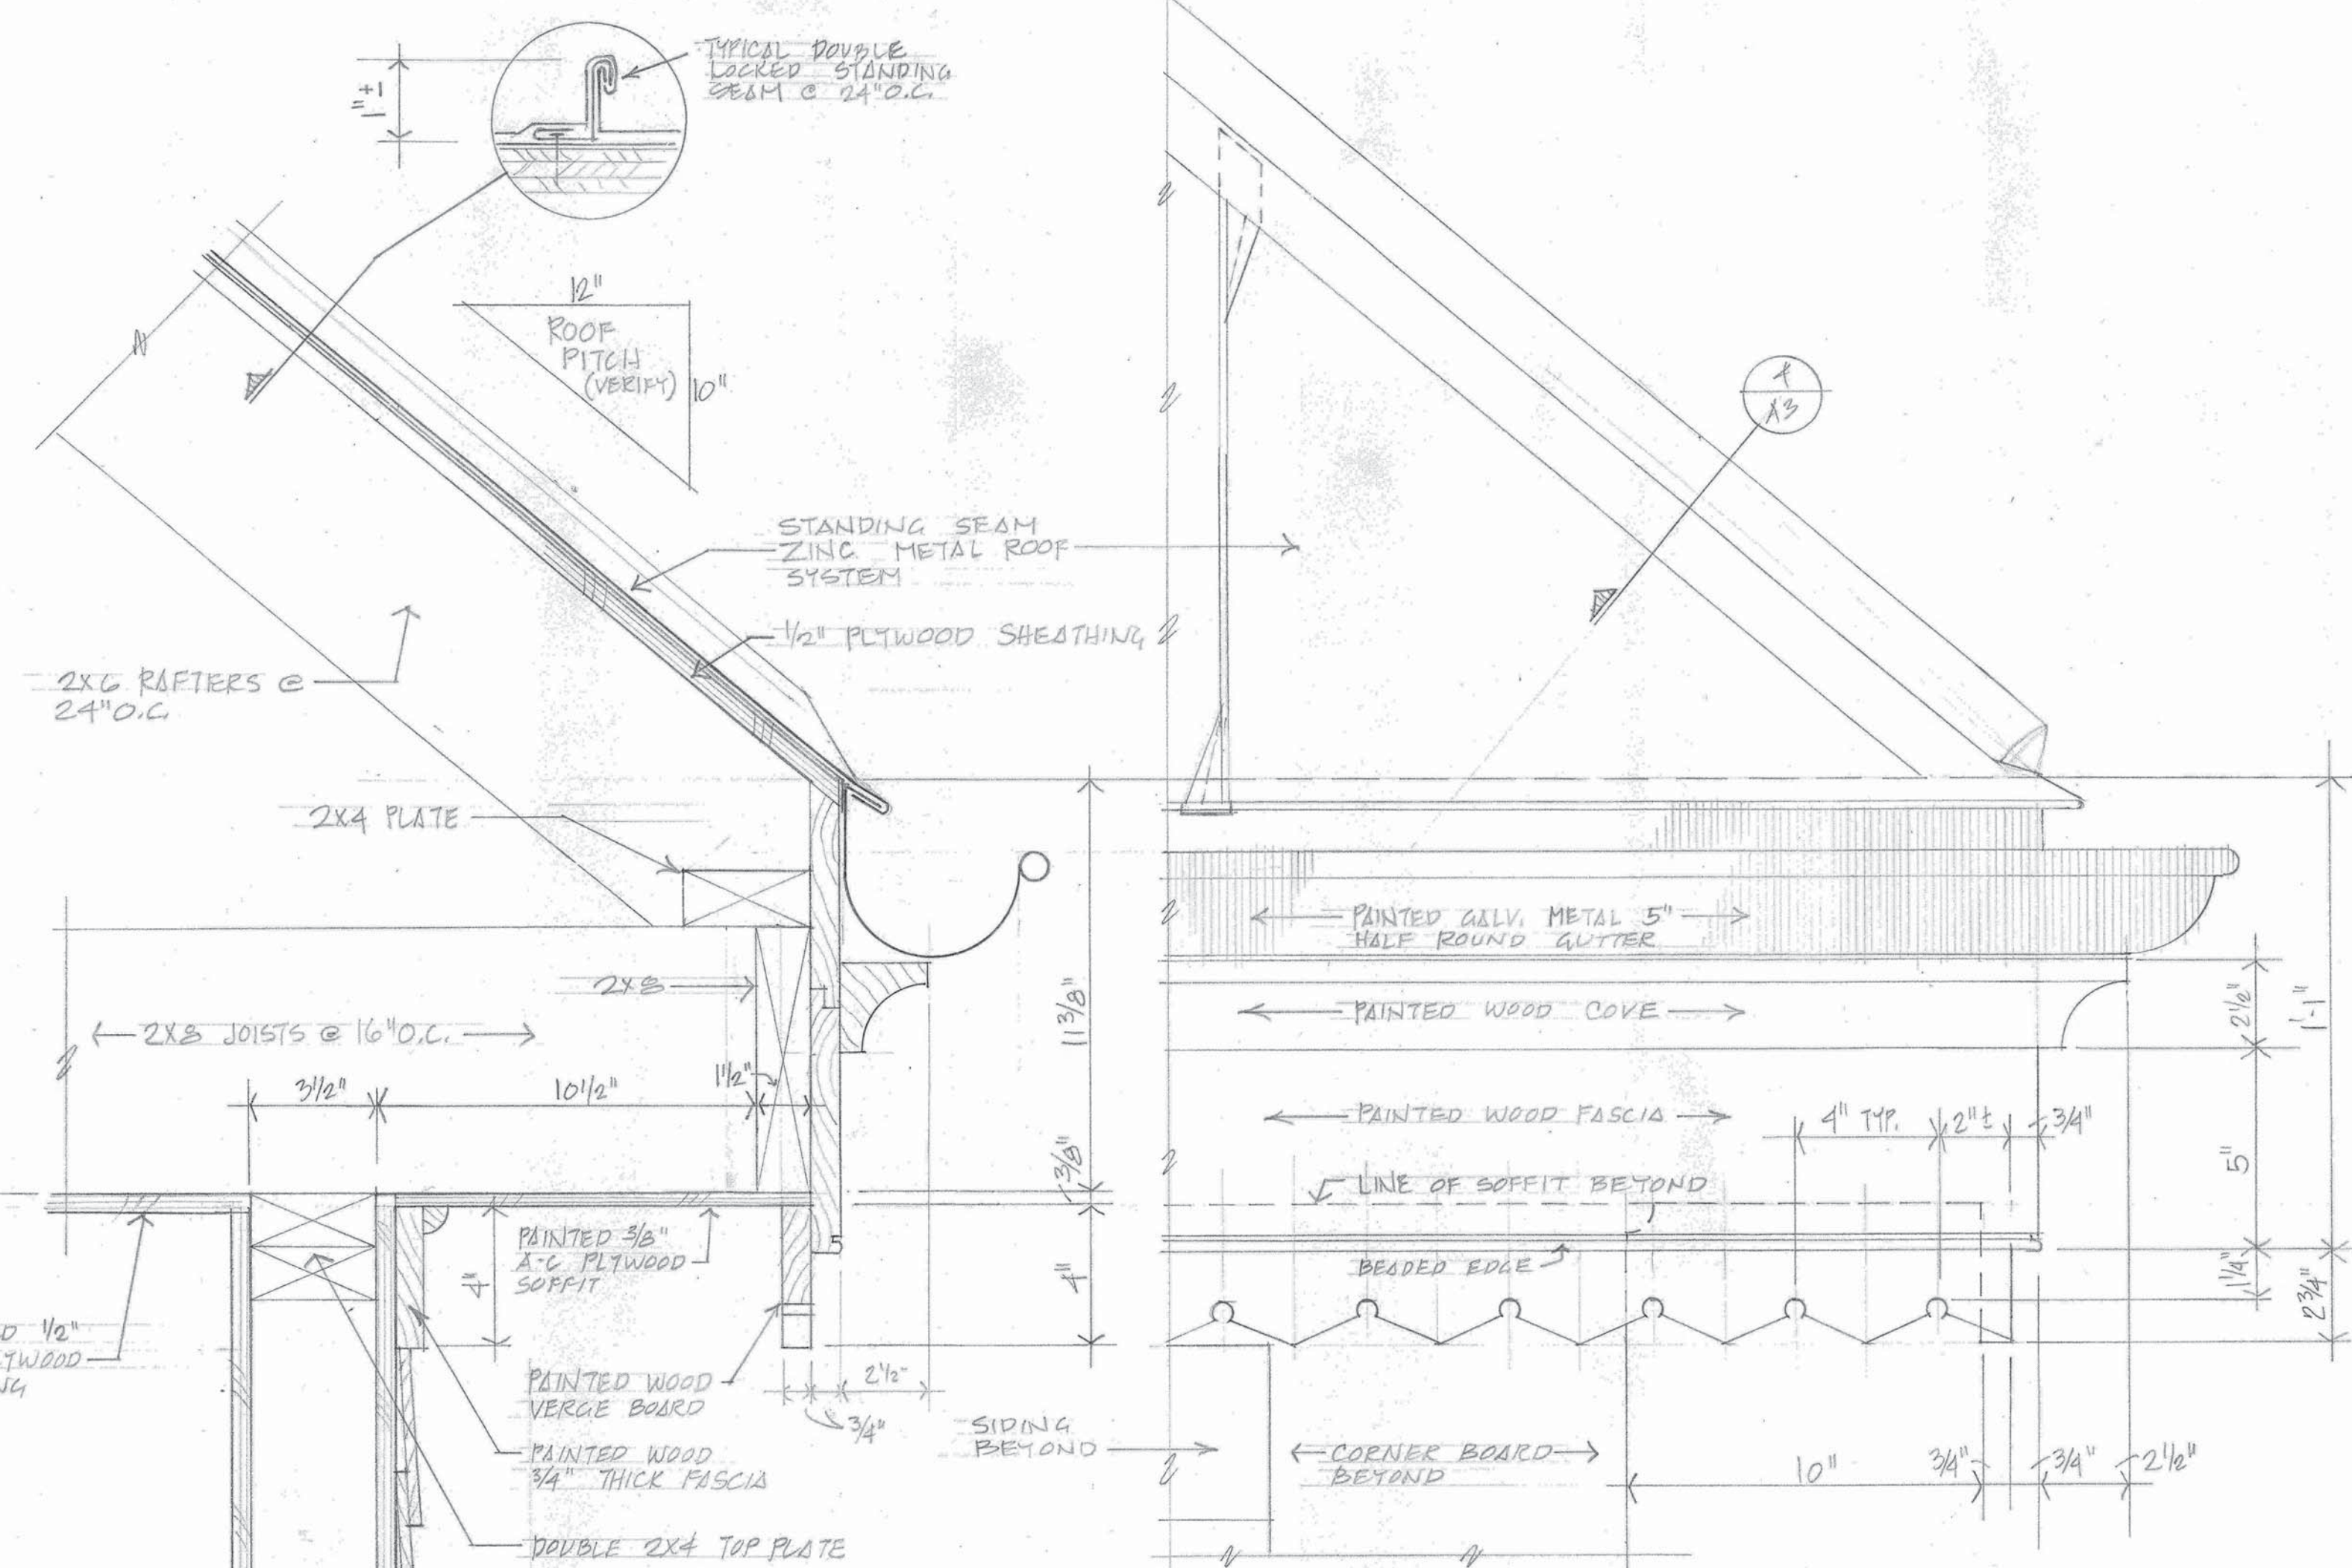


1 HIP DETAIL  
SCALE: 3"=1'-0"

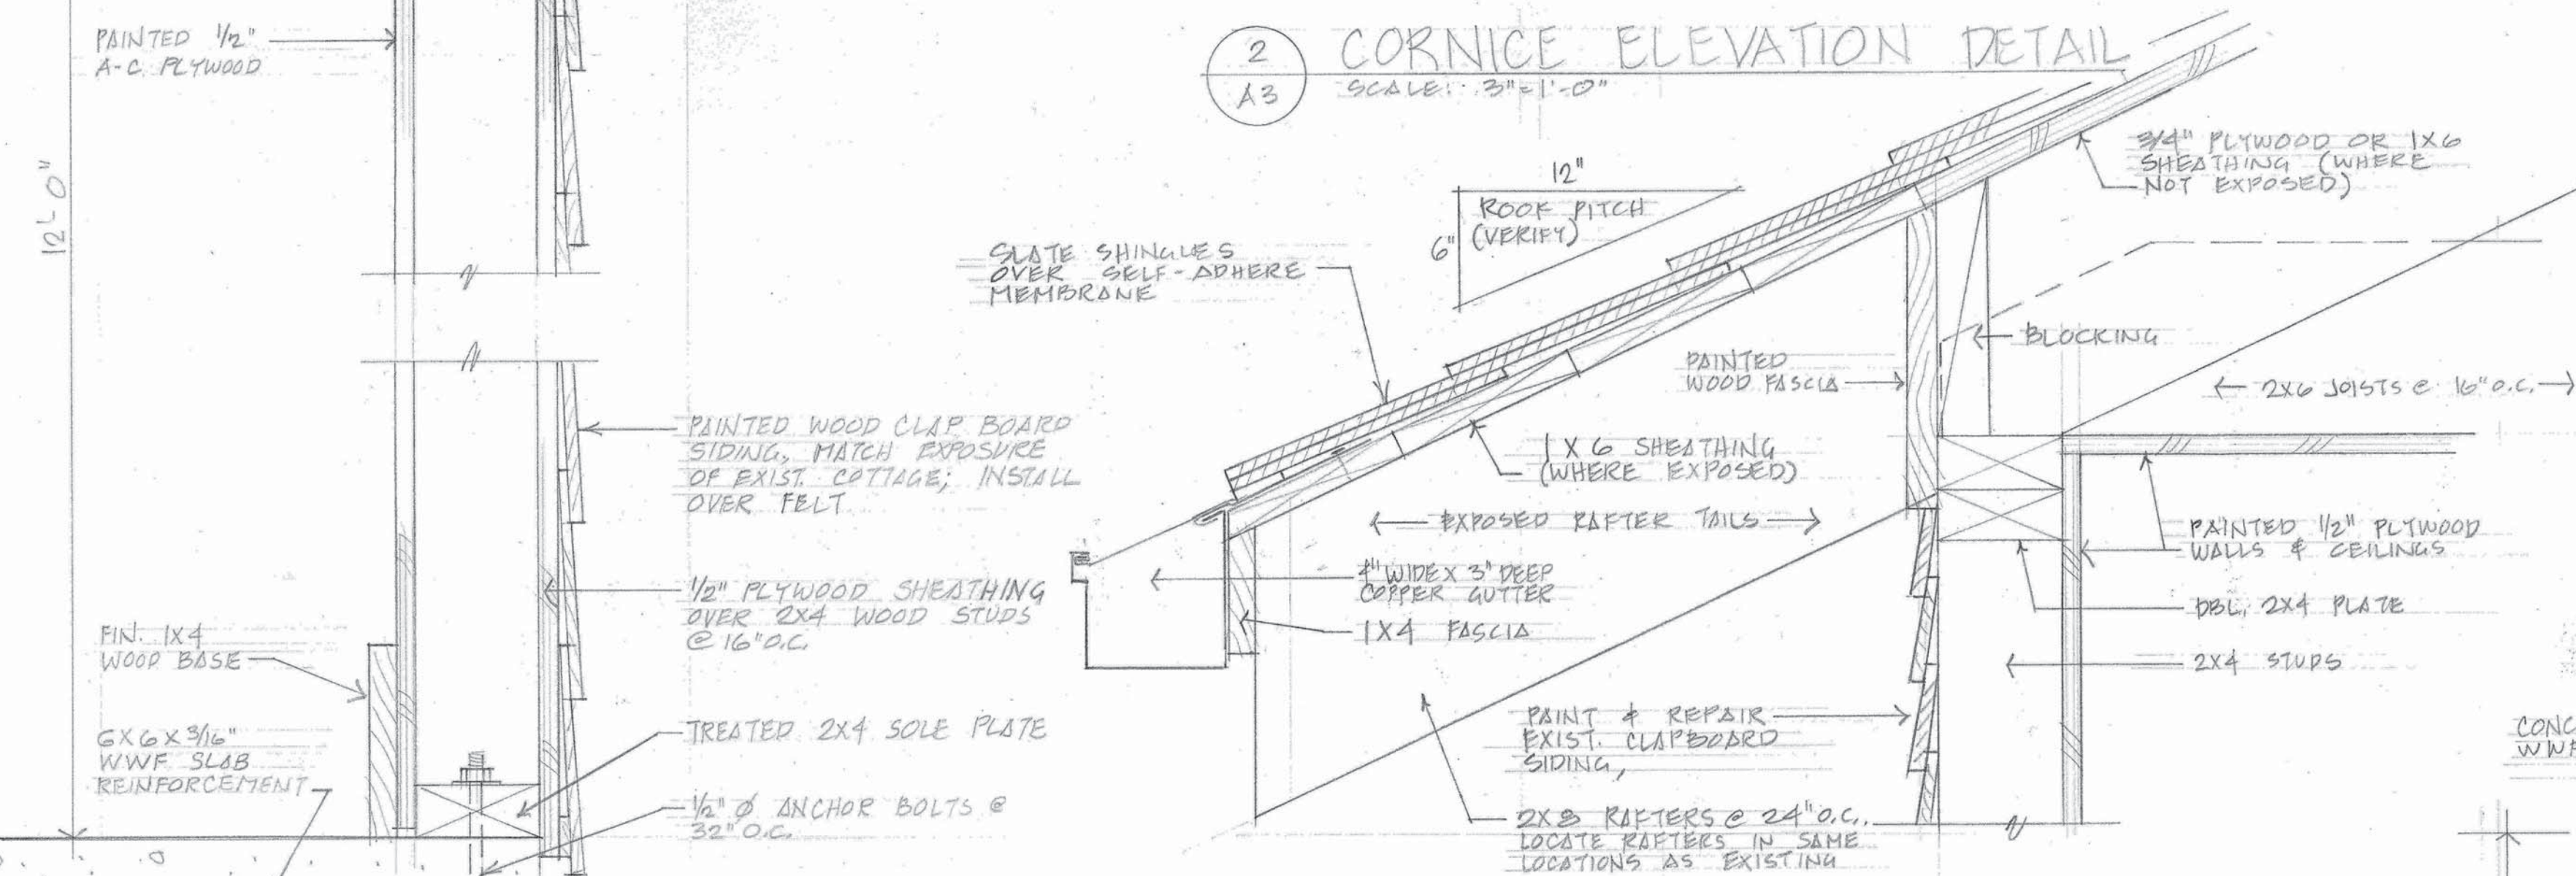


2 CORNICE ELEVATION DETAIL  
SCALE: 3"=1'-0"

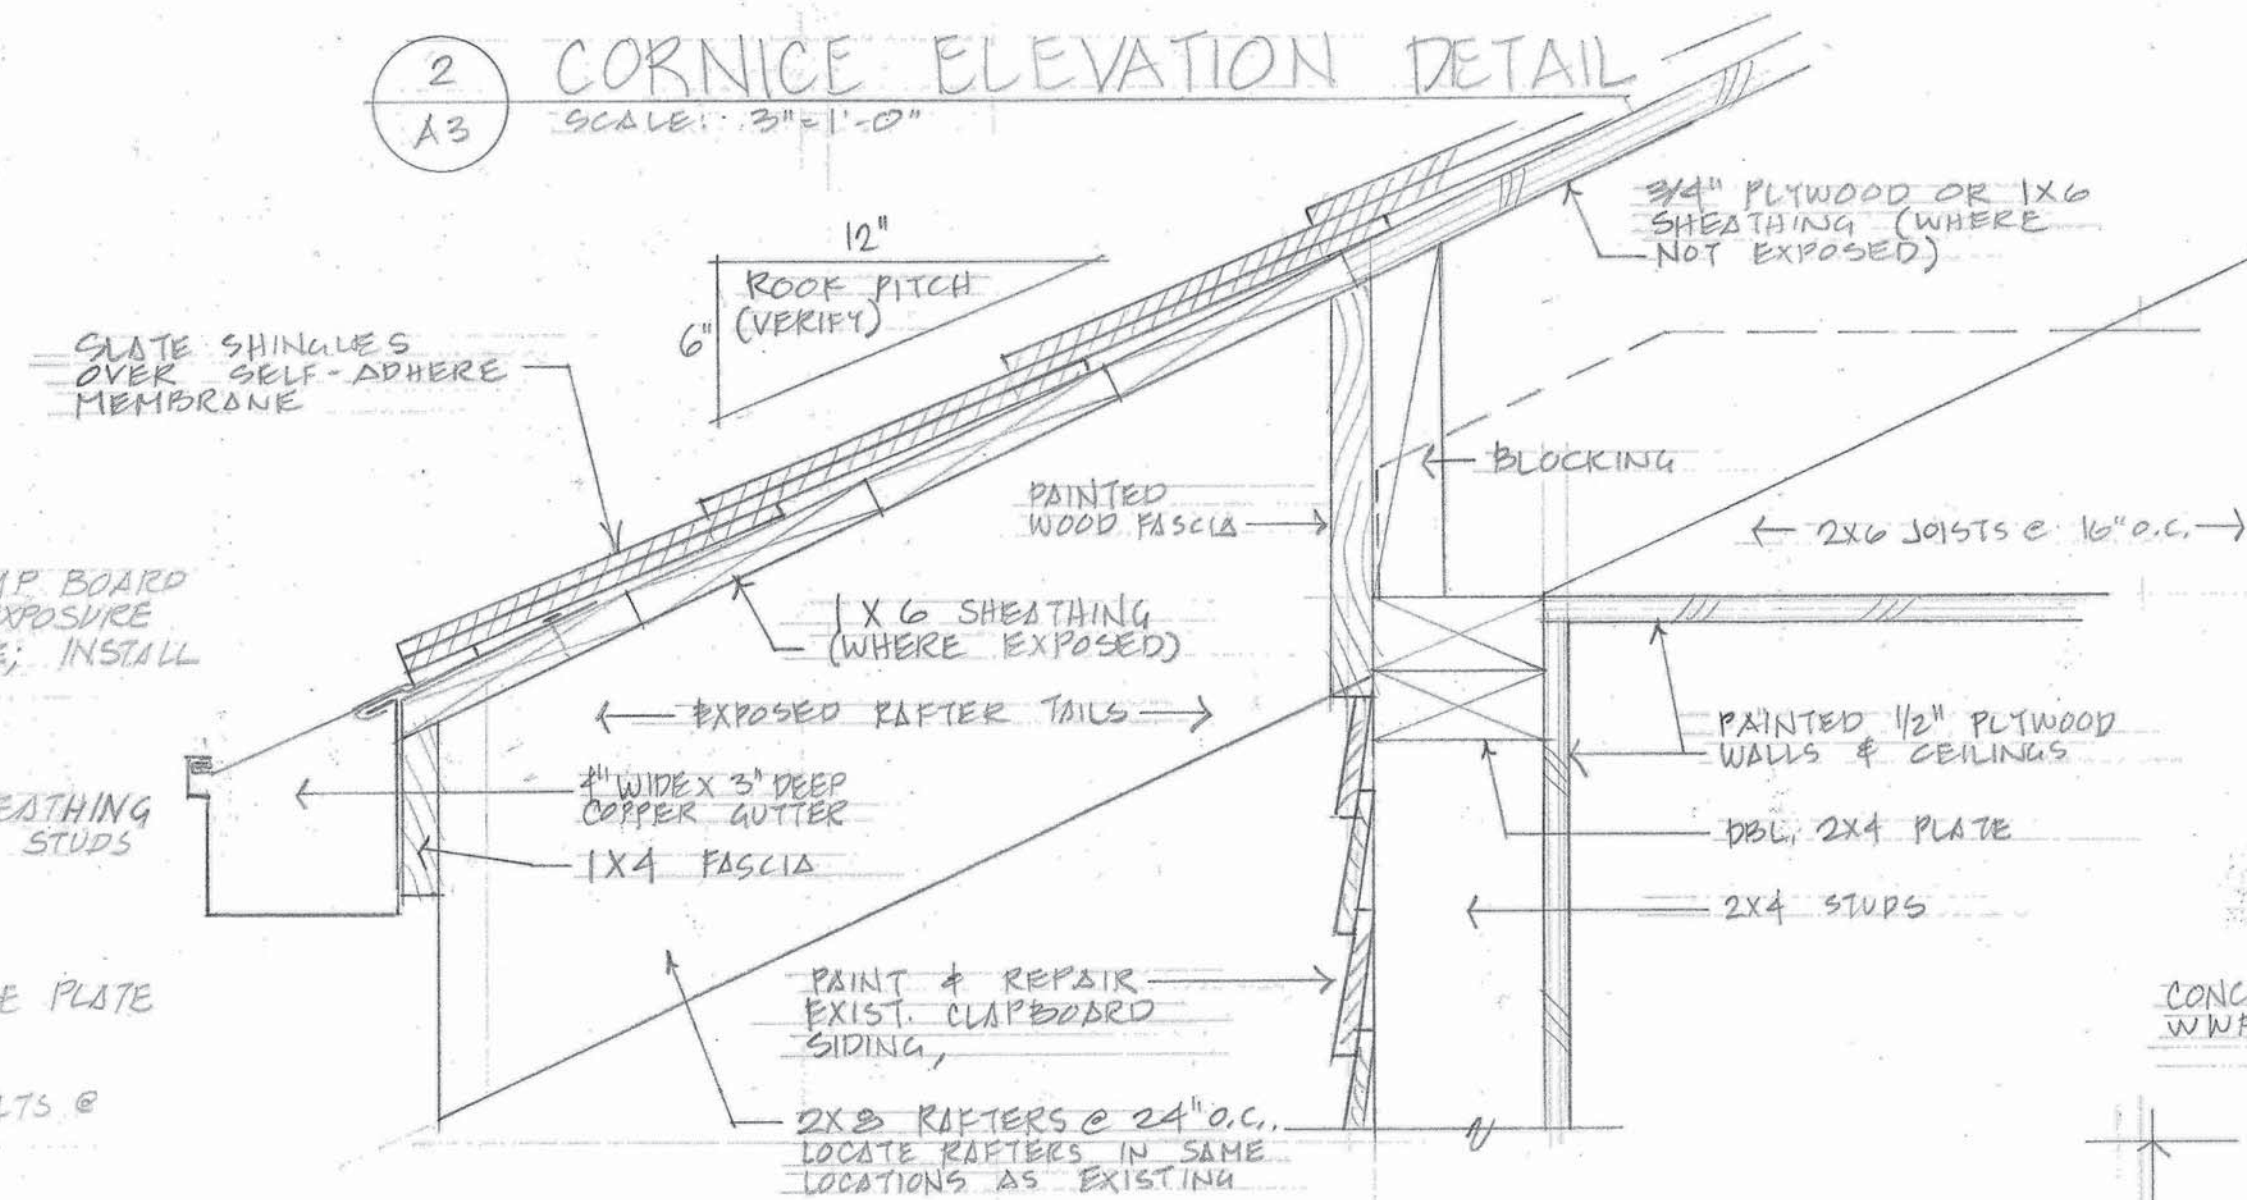


3 LAFAYETTE NO. 1 COTTAGE OVERHANG  
SCALE: 3"=1'-0"

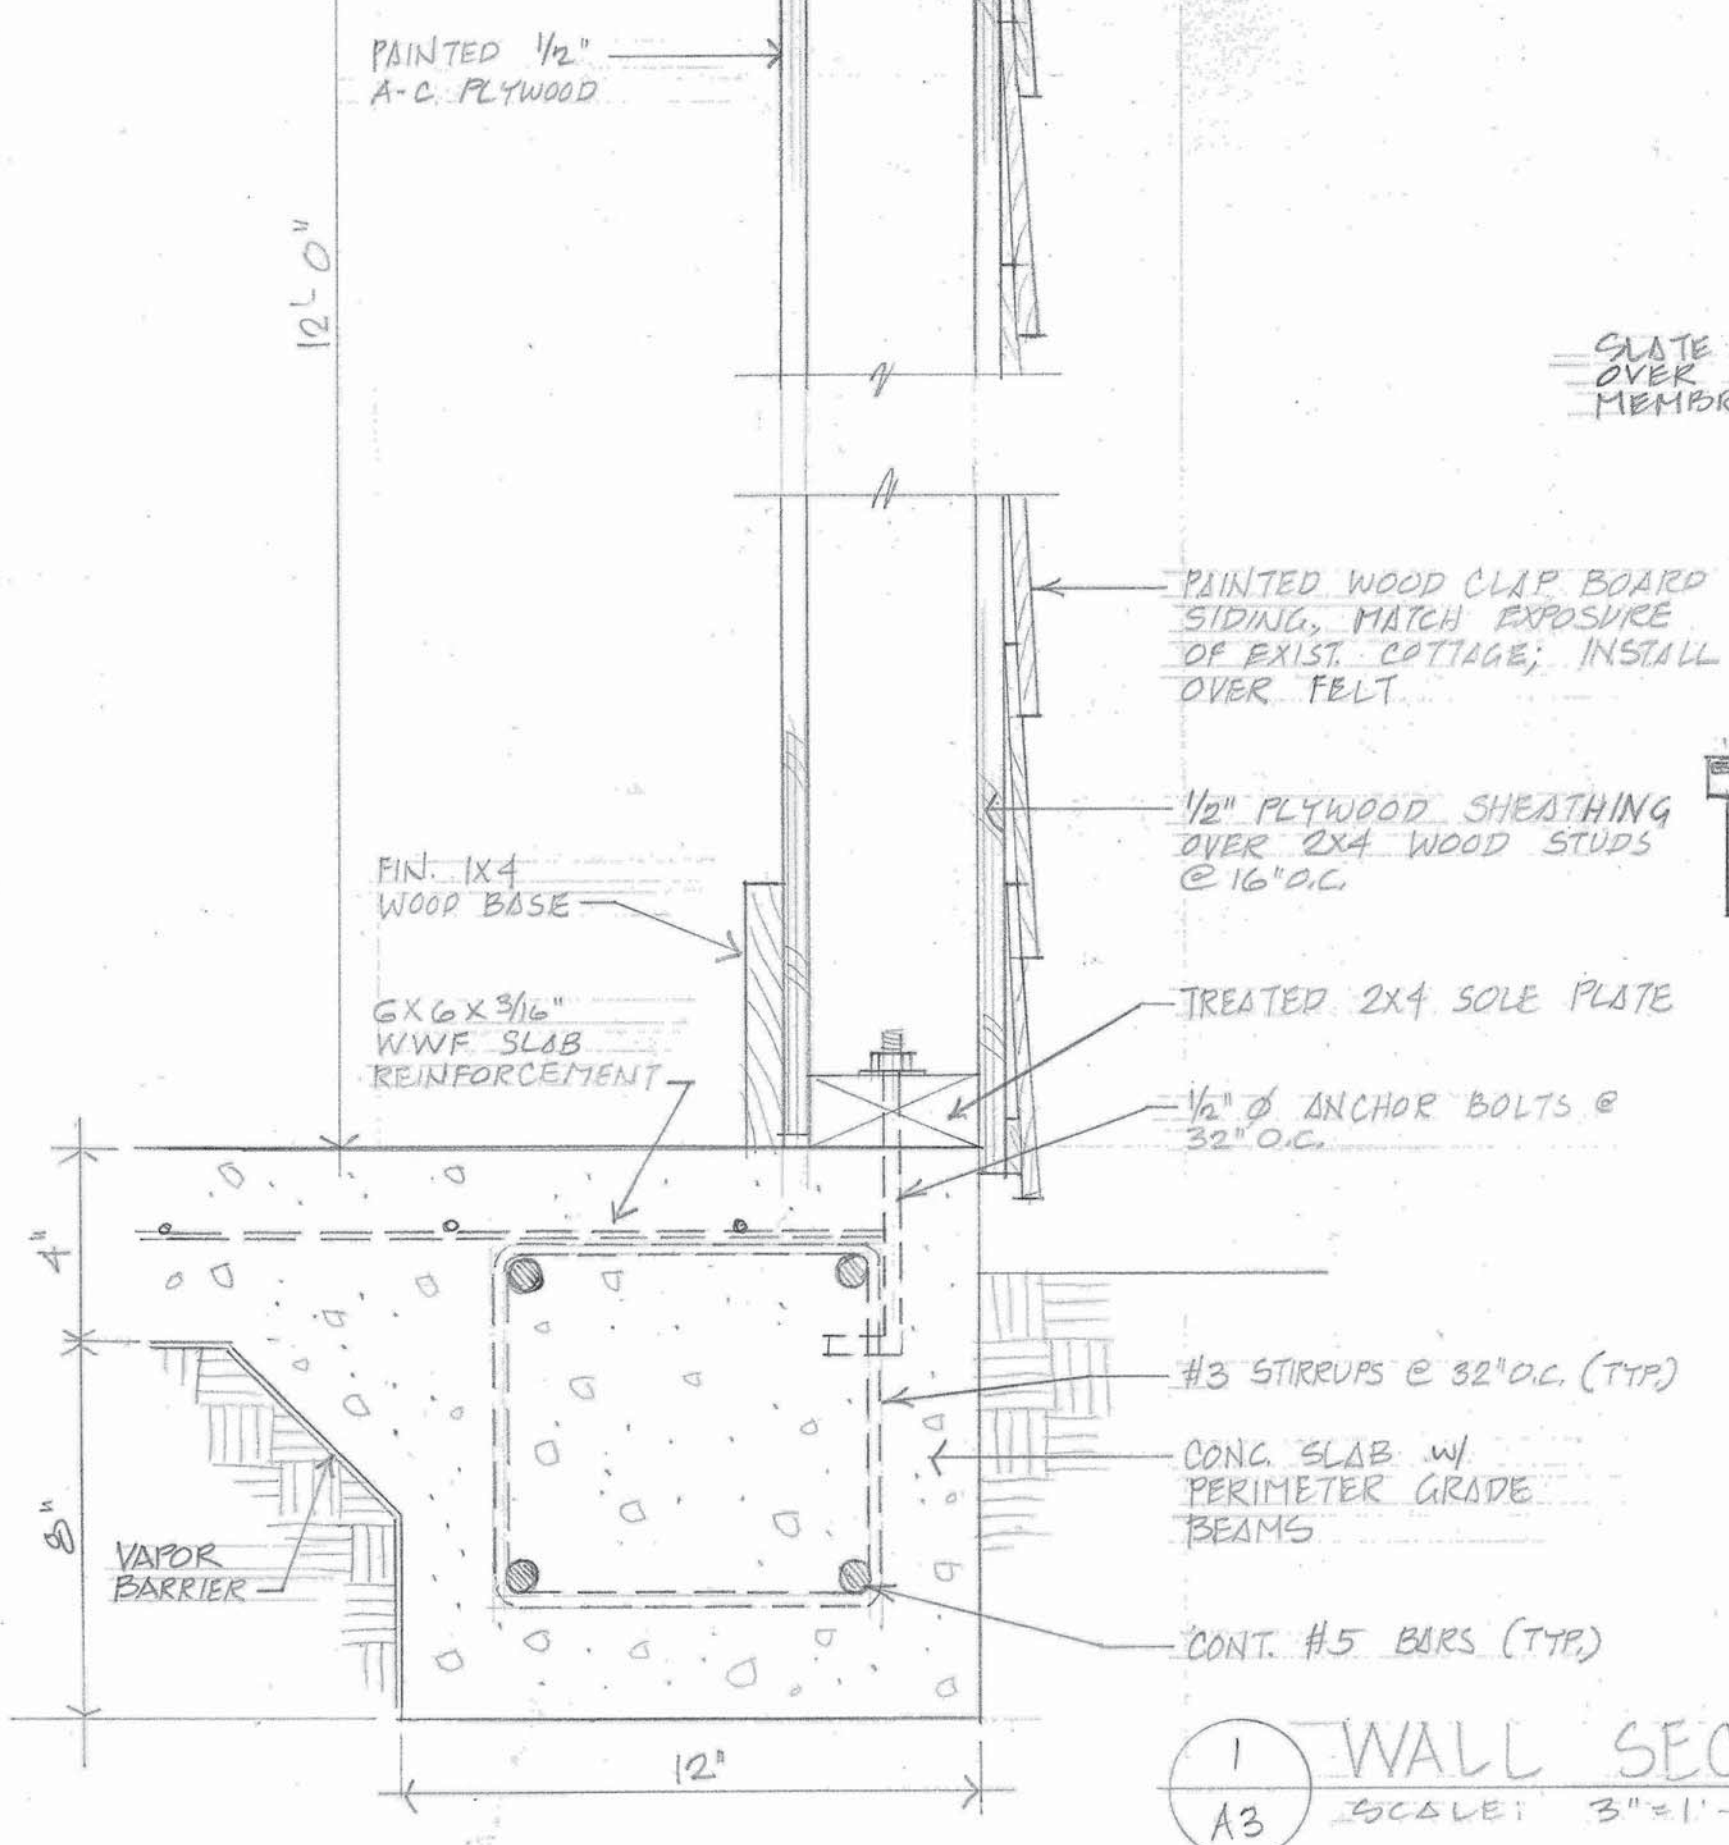

1 WALL SECTION - NEW COTTAGE (LAFAYETTE No. 2)  
SCALE: 3"=1'-0"

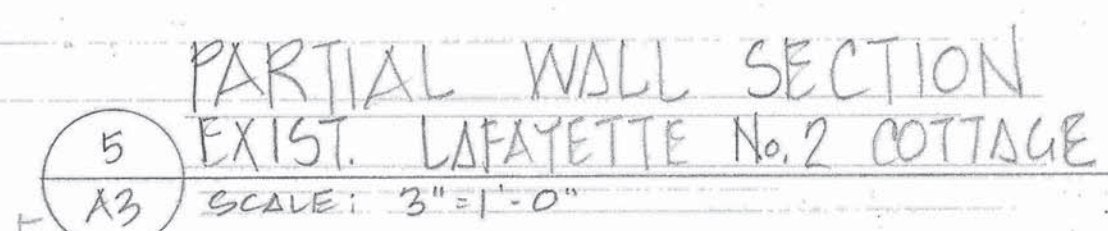

5 PARTIAL WALL SECTION EXIST. LAFAYETTE No. 2 COTTAGE  
SCALE: 3"=1'-0"

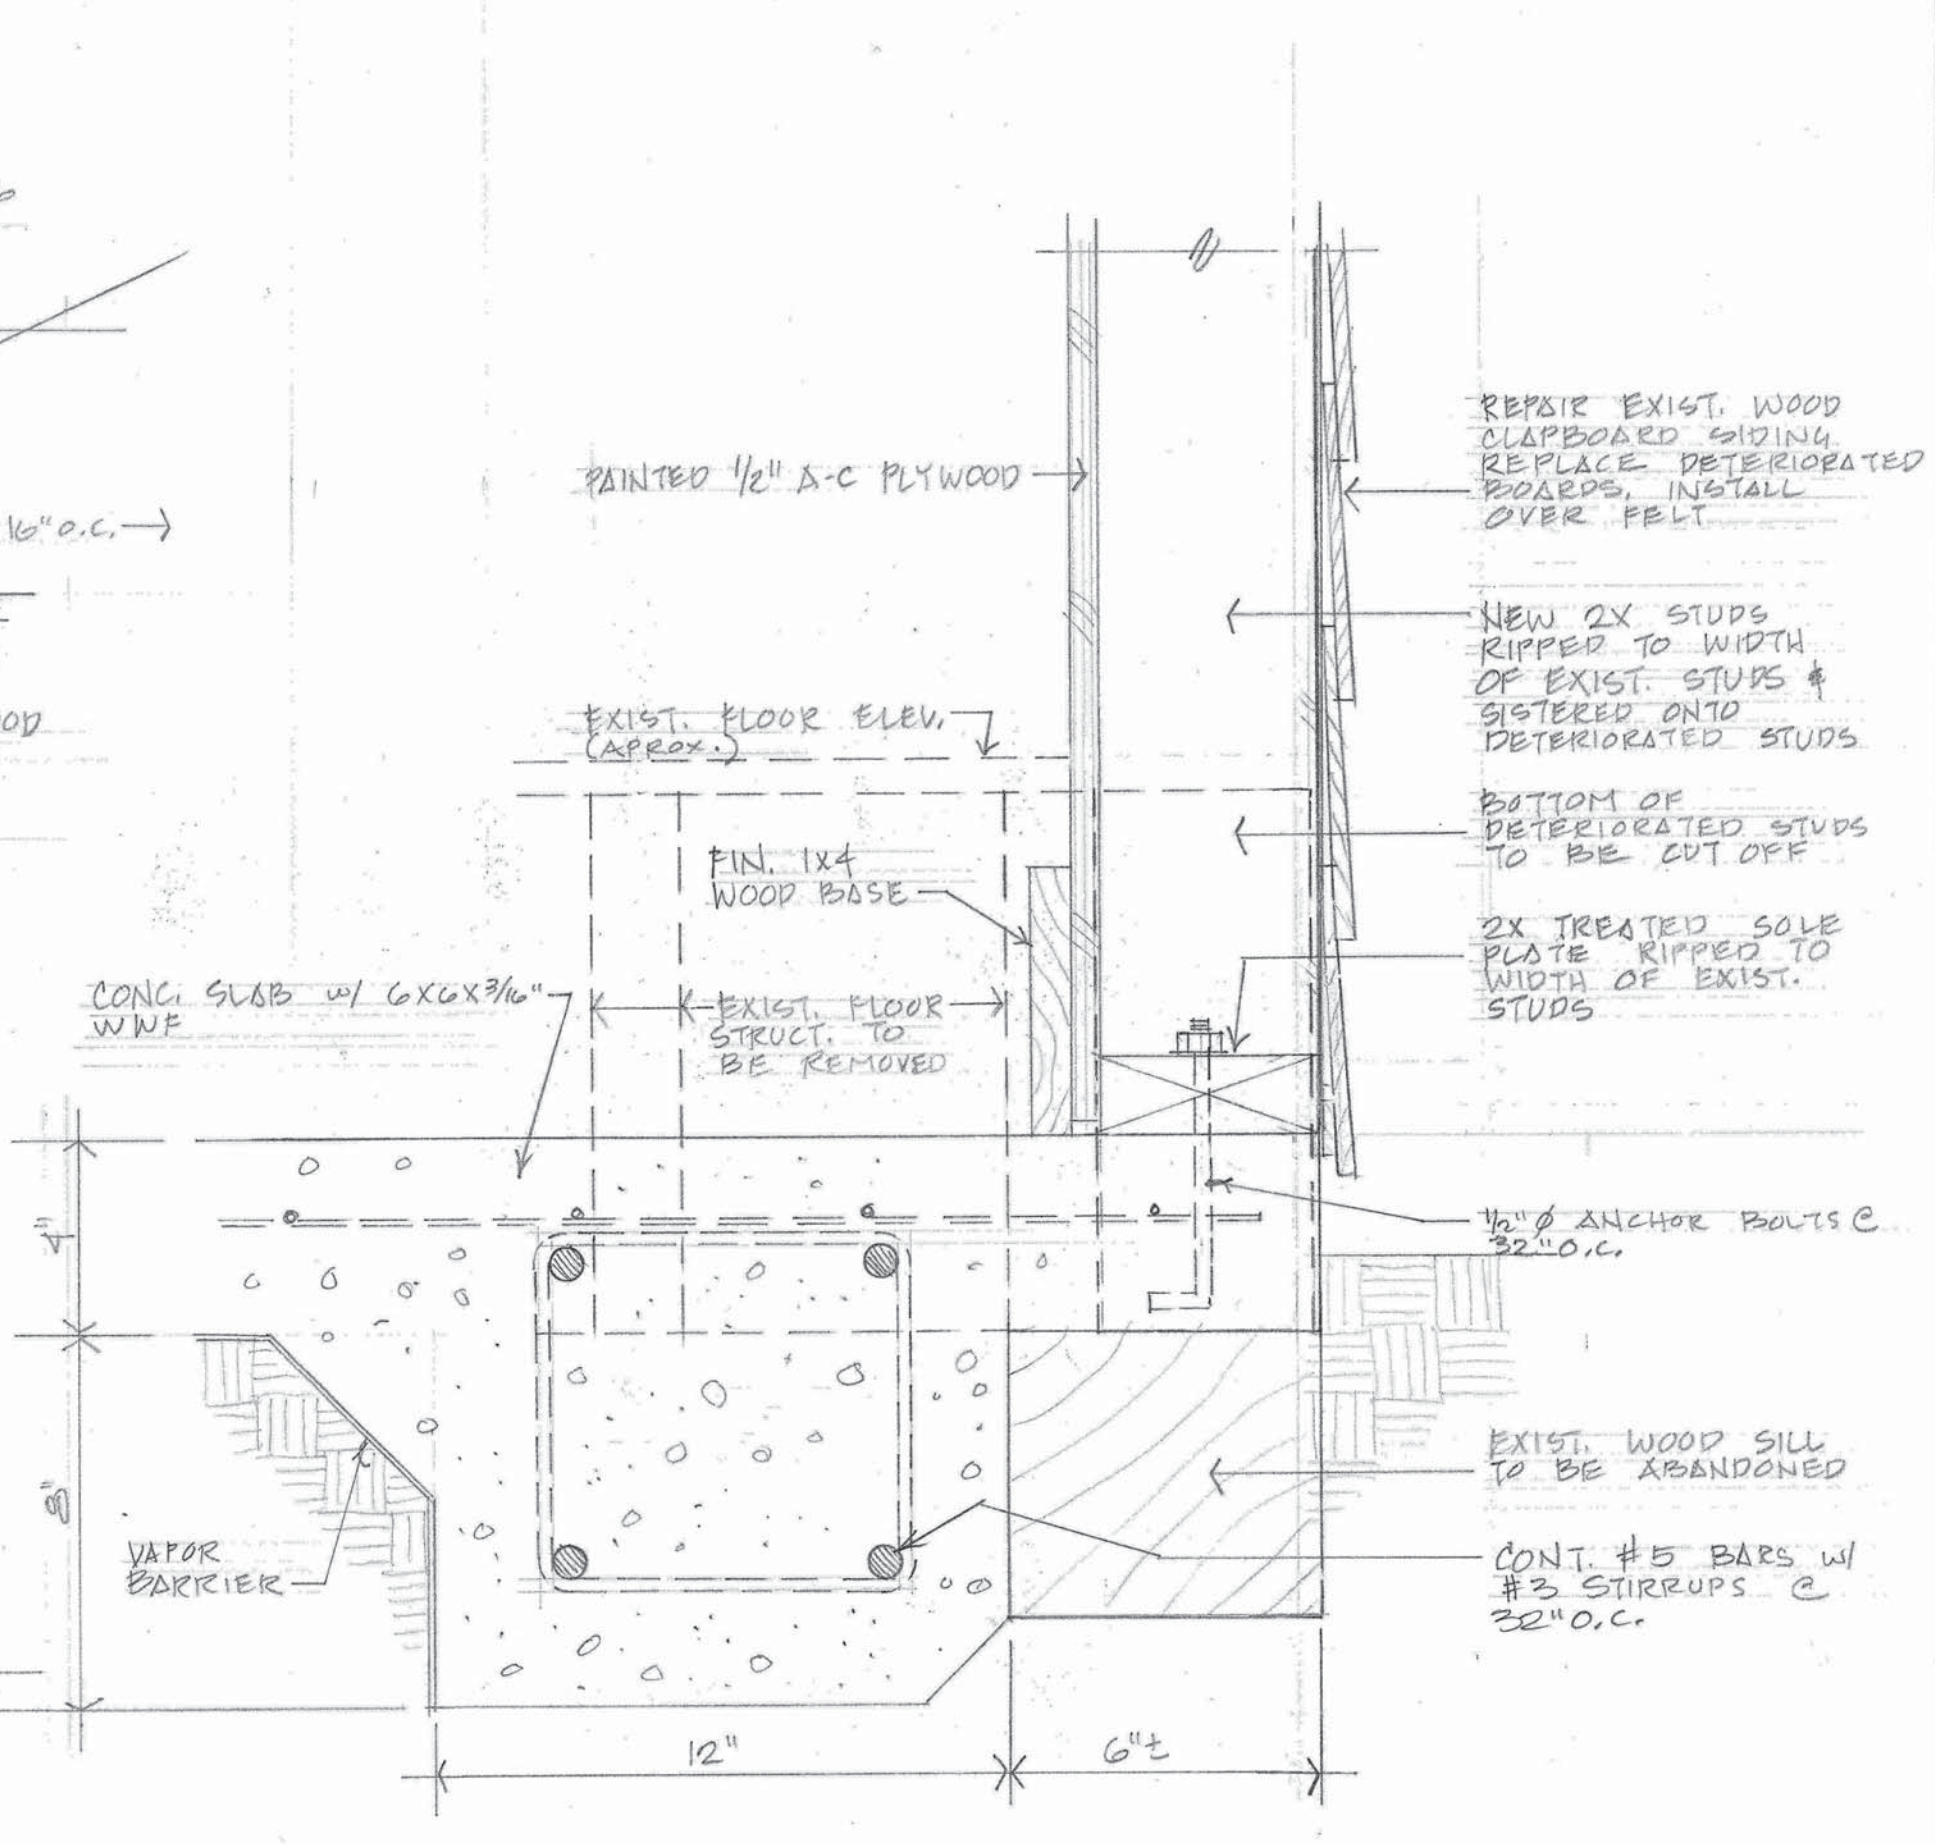

Restoration of Sexton Cottages  
Lafayette Cemetery No. 1 & 2  
New Orleans, Louisiana

PROJECT #		
TYPE		
DRAWN BY	MR	
CHECKED BY		
ISSUE DATE	1/24/2013	
REVISION #	DESCRIPTION DATE	


A-3

These drawings were prepared by me, or under my  
close personal supervision, and to my best  
knowledge and belief comply with all City codes  
and ordinances. I am not administering the  
work.


John L. Schackal, III Architect Reg. No. 2990

MAIN SIZE: 150 AMPS VOLTS / PHASE: 150/240; 1 PH; 3W MOUNTING: SURFACE LOCATION: EXTERIOR											
PANEL #1 (LAFAYETTE CEMETERY NO. 1 COTTAGE)											
CKT.	BRK.	WIRE	DESCRIPTION	WATTS		DESCRIPTION	WIRE	BRK.	CKT.		
				A	C					A	C
1	20	12	LIGHTING	500		RECEPTACLES	12	20	2		
3	20	12	WATER HEATER		750						
FEEDER:				500	750	1500					
				A = 2000 WATTS = 9 AMPS				C = 1500 WATTS = 4 AMPS			

MAIN SIZE: 150 AMPS VOLTS / PHASE: 150/240; 1 PH; 3W MOUNTING: SURFACE LOCATION: EXTERIOR												
PANEL #2 (LAFAYETTE CEMETERY NO. 2 COTTAGE(S))												
CKT.	BRK.	WIRE	DESCRIPTION	WATTS		DESCRIPTION	WIRE	BRK.	CKT.			
				A	C					A	C	
1	20	12	LIGHTING	250		RECEPTACLES	12	20	2			
3	20	12	WATER HEATER		750							
5	20	12	RECEPTACLES (ALT #1)	1500		LIGHTING (ALT #1)	12	20	4			
FEEDER				1750	750	1500	250					
				A = 3250 WATTS = 14 AMPS				C = 1020 WATTS = 5 AMPS				

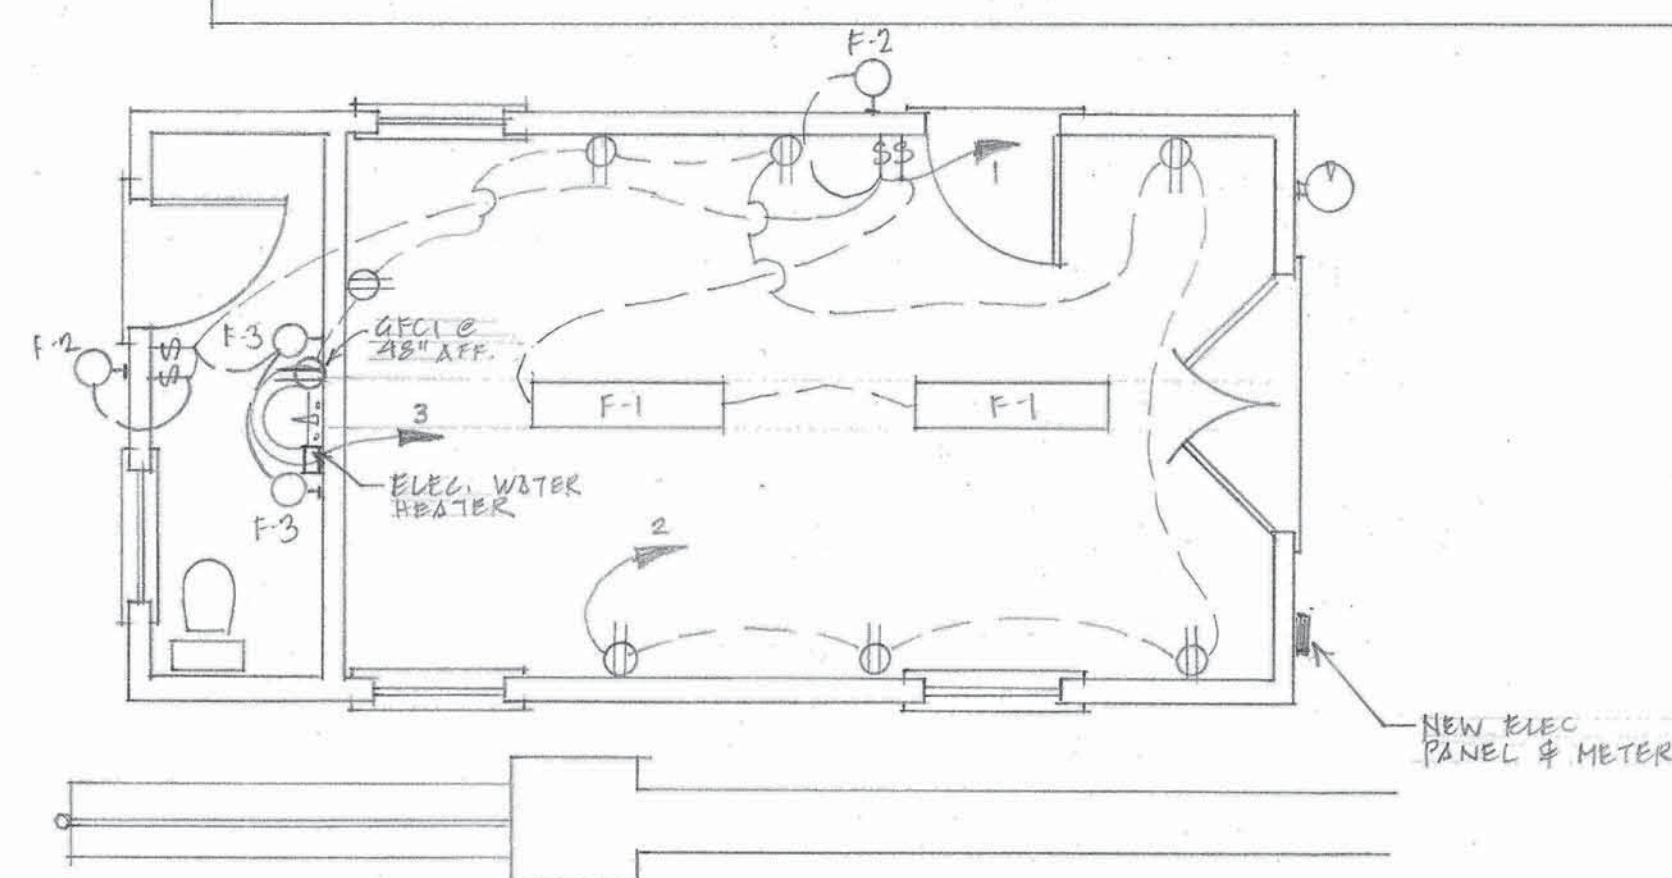

1 ELECTRICAL FLOOR PLAN - LAFAYETTE No. 1  
SCALE: 1/4" = 1'-0"

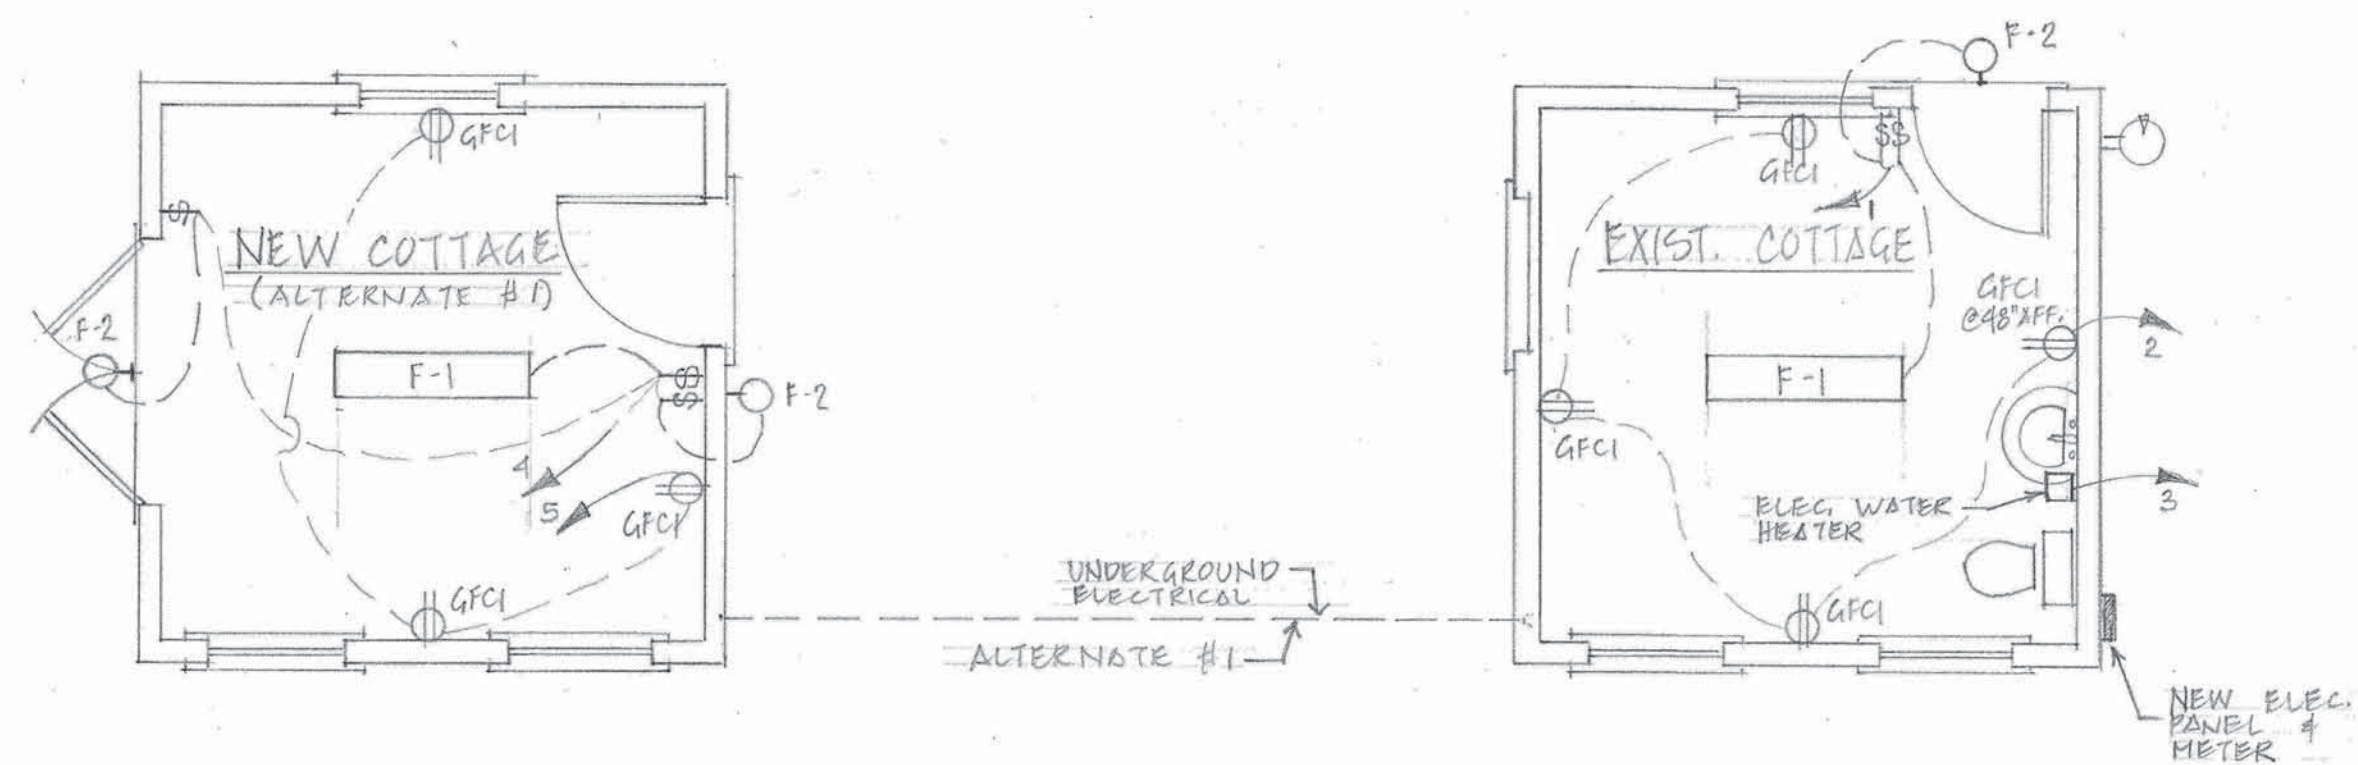

2 ELECTRICAL FLOOR PLAN - LAFAYETTE No. 2  
SCALE: 1/4" = 1'-0"

Restoration of Sexton Cottages  
Lafayette Cemetery No. 1 & 2  
New Orleans, Louisiana

PROJECT #		
TYPE		
DRAWN BY	MR	
CHECKED BY		
ISSUE DATE	1/24/2013	
REVISION #	DESCRIPTION DATE	

E-1